

CAUTION:
THE POSITION OF POLE LINES, CONDUITS, WATERMAINS, SEWERS AND
OTHER UNDERGROUND AND OVERGROUND UTILITIES AND STRUCTURES IS
NOT NECESSARILY SHOWN ON THE DRAWINGS, AND, WHERE SHOWN, THE
ACCURACY OF THE POSITION OF SUCH UTILITIES AND STRUCTURES IS
NOT GUARANTEED. BEFORE STARTING WORK, THE CONTRACTOR SHALL
INFORM THEMSELF OF THE EXACT LOCATION OF ALL SUCH UTILITIES AND
STRUCTURES, AND SHALL ASSUME ALL LIABILITY FOR DAMAGE TO THEM.

HANOVER POLICE STATION

TOWN OF HANOVER




CONTRACT NO. 26-10048-01

MAYOR : MS. SUE PATERSON
CHIEF ADMINISTRATIVE OFFICER : MS. SHERRI WALDEN
DIRECTOR OF DEVELOPMENT & INFRASTRUCTURE / CHIEF BUILDING OFFICIAL : MR. ANDREW WILKEN

OWNER : TOWN OF HANOVER


Index

<u>SHEET No.</u>	<u>DESCRIPTION</u>
10048-C1	EXISTING CONDITIONS AND REMOVALS
10048-C2	PROPOSED SITE PLAN
10048-C3	PROPOSED SITE SERVICING
10048-C4	PROPOSED SITE GRADING
10048-C5	STORM SEWER CATCHMENT AREAS
10048-DET1	DETAILS 1
10048-DET2	DETAILS 2

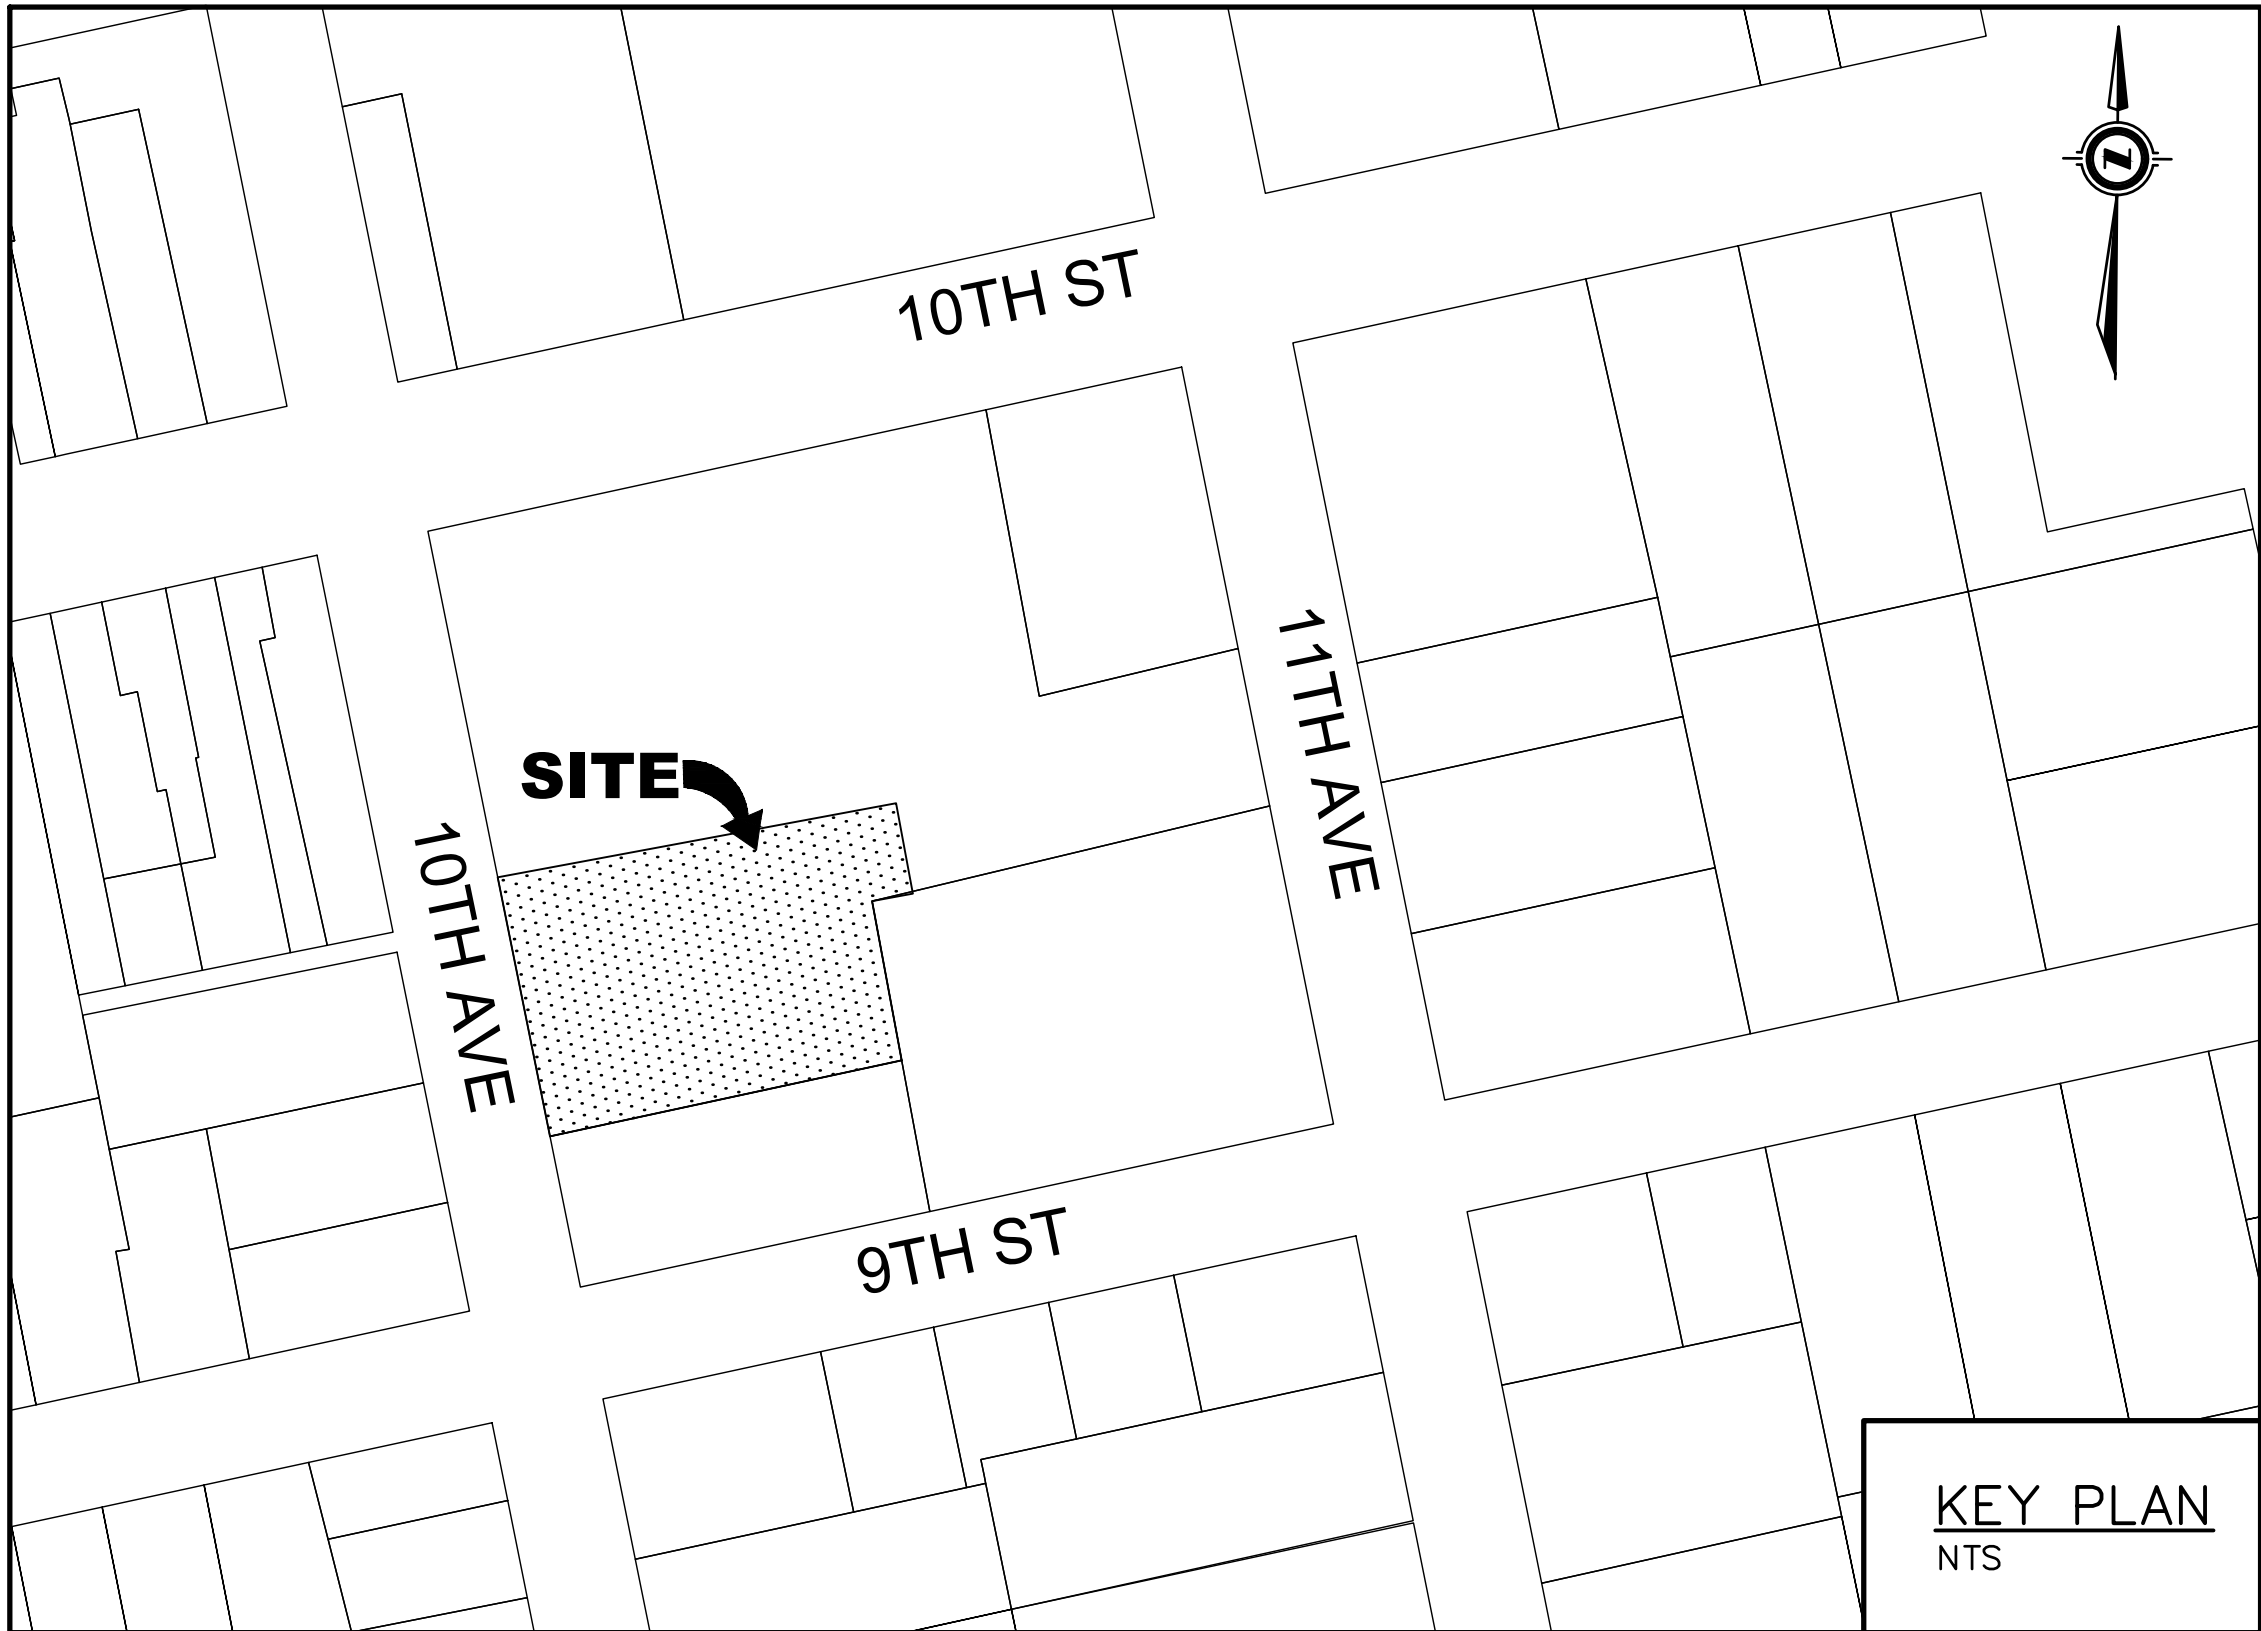

3	AUG 13/26	ISSUED FOR TENDER	JHL	TLB	
2	JUN 10/26	SECOND SUBMISSION	JHL	TLB	
1	APR 10/26	FIRST SUBMISSION	JHL	TLB	
No.	DATE	DESCRIPTION	BY	APPD	
REVISION / ISSUE					
Seal not valid unless signed and dated					
517 10th Street, Hanover, Ontario N4N 1R4 Telephone: (519) 506-5959 www.cobideeng.com					
Title: 341 10TH STREET TOWN OF HANOVER HANOVER POLICE STATION TITLE SHEET					
Client: +VG ARCHITECTS					
Design: TLB		Scale: 1:200			
Drawn: SEH/JHL		Approved:			
Checked: TLB					
Date: MAR 2026		Design Engineer			
DRAWING No.		10048-TS			

H:\Hanover\10048 - Hanover Police Station\Drawings\Submissions\2026-08-13 Issued for Tender\10048 - Hanover Police Station - 2026-08-10.dwg

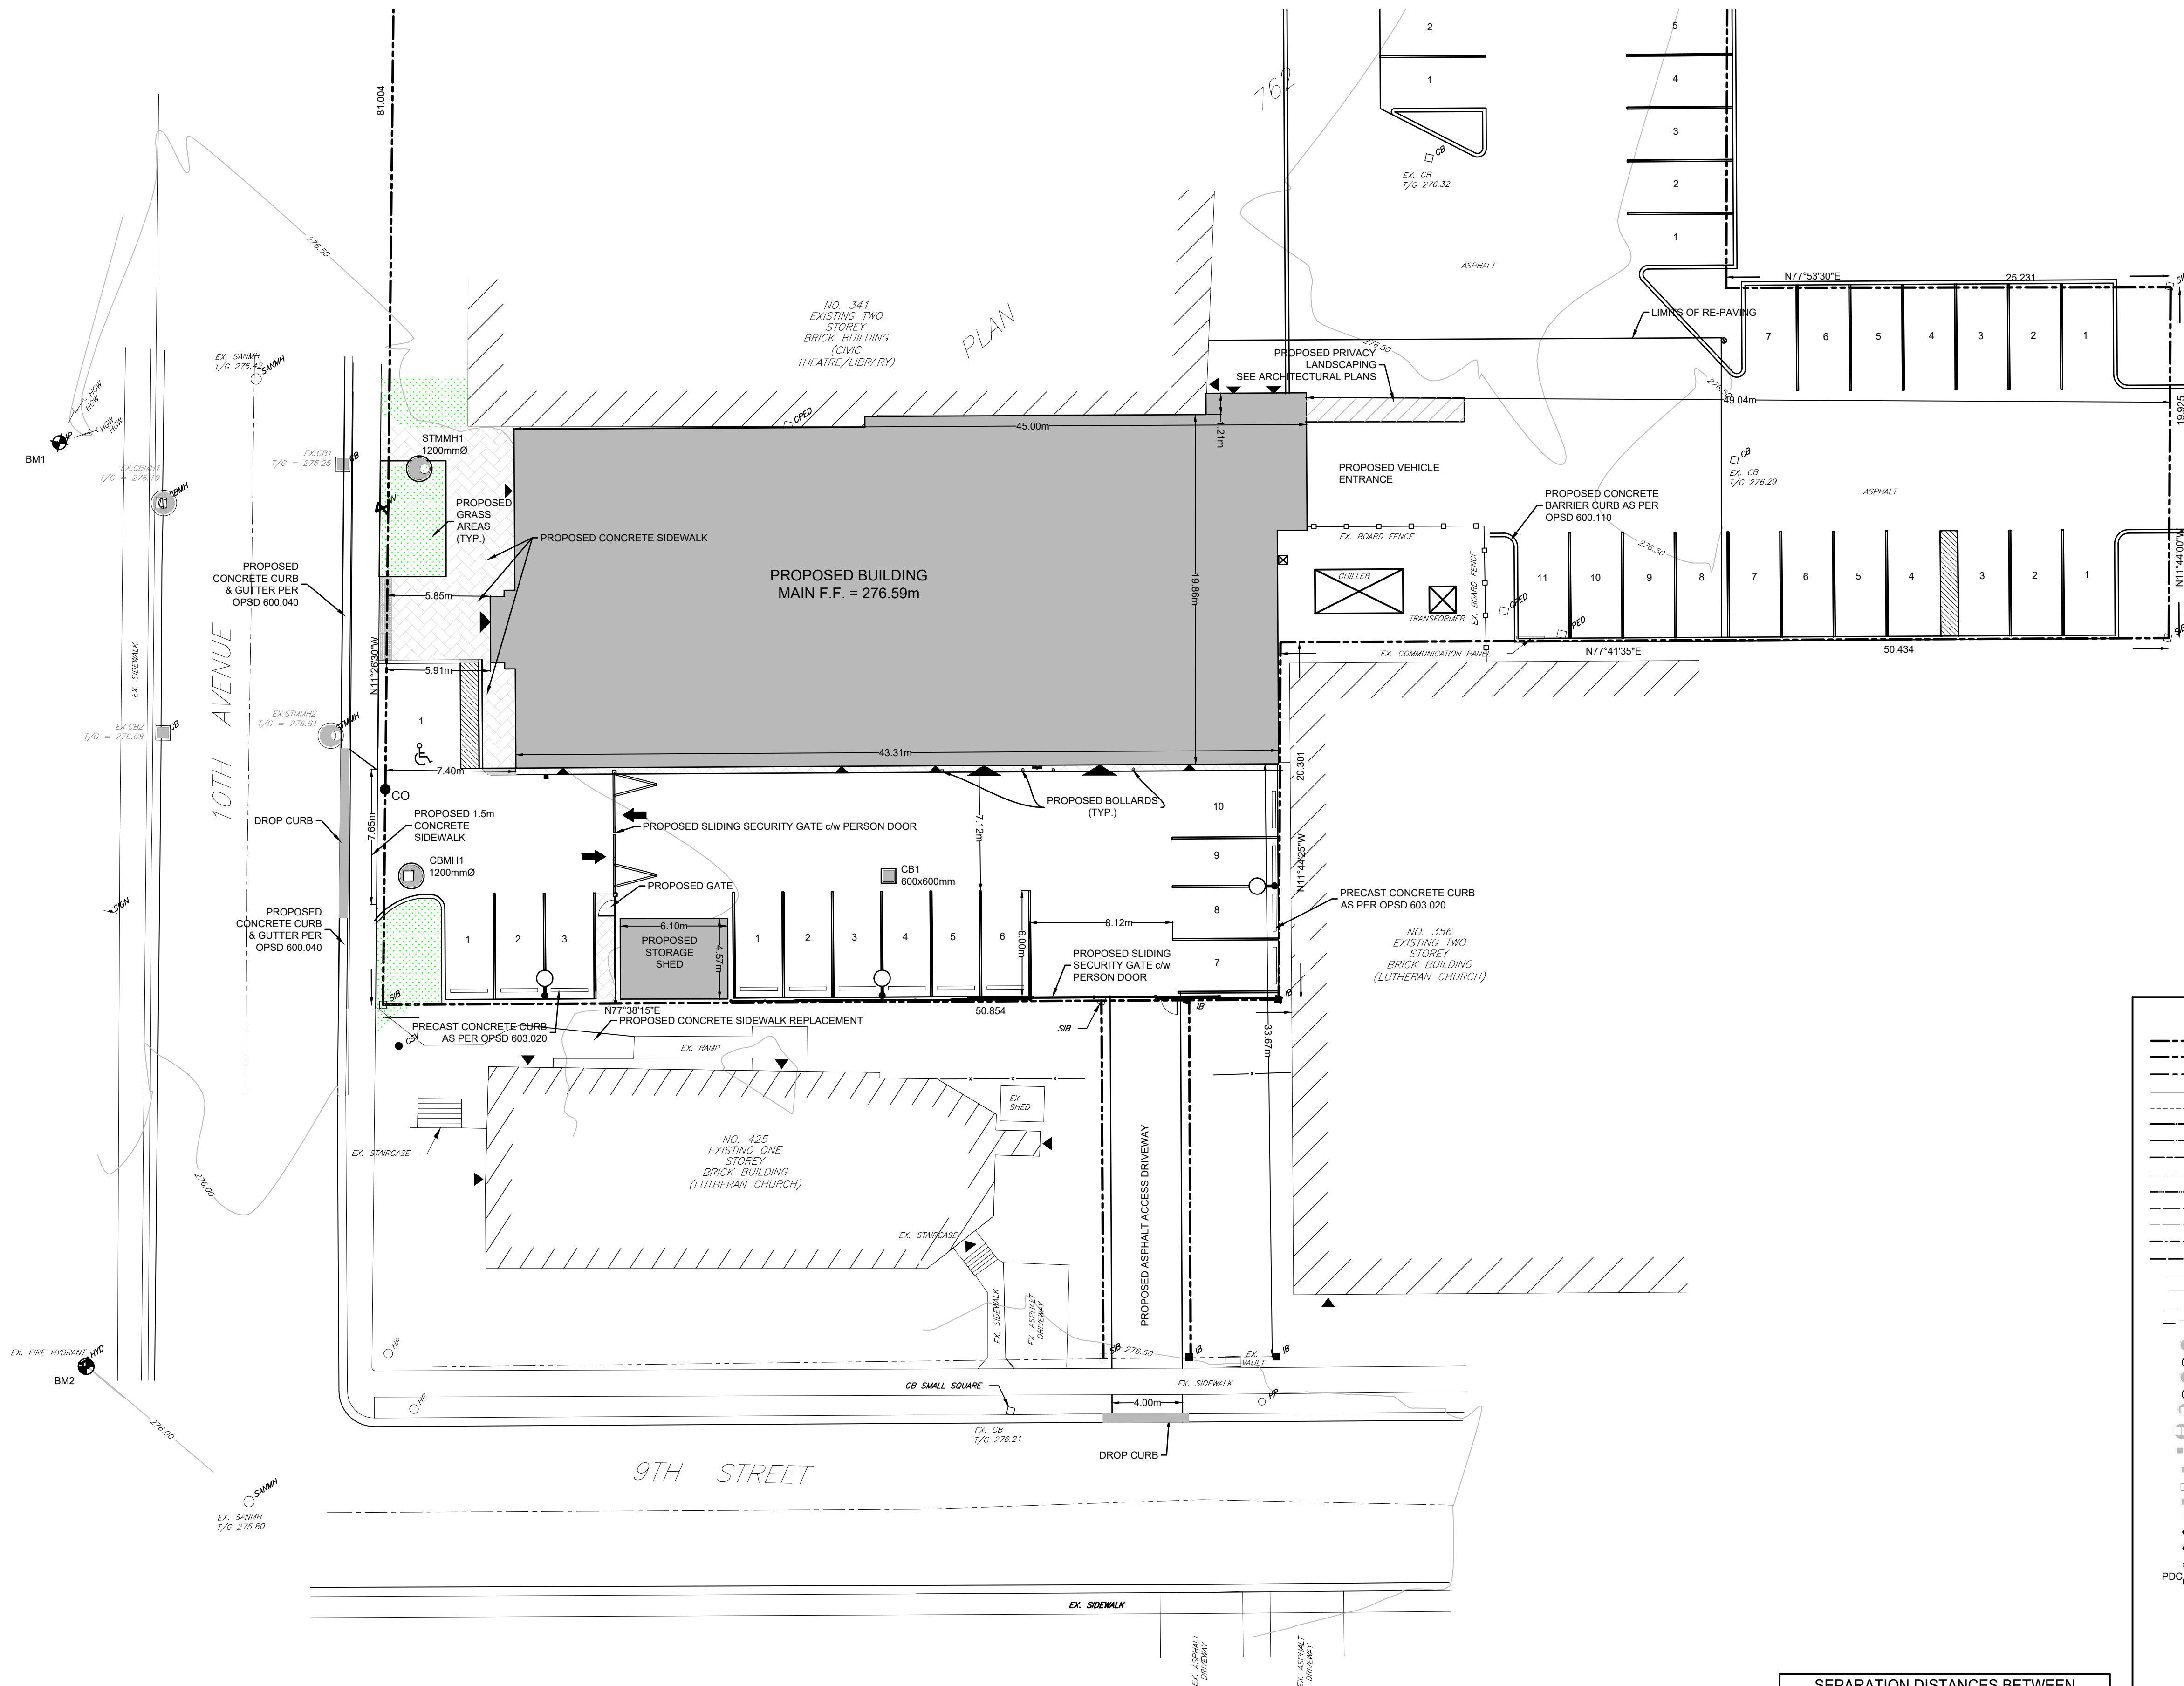



SEPARATION DISTANCES BETWEEN SEWERS/SEWER SERVICES AND WATERMAIN/WATER SERVICES SHALL BE AS PER MECP PROCEDURE F-6-1; IN GENERAL, 2.5m MINIMUM HORIZONTAL SEPARATION BETWEEN PARALLEL INSTALLATIONS AND 0.5m VERTICAL SEPARATION AT CROSSINGS WHERE THE WATERMAIN OR WATER SERVICE CROSSES UNDER THE SEWER/SERVICE AND PLACE WATER PIPE JOINTS A MINIMUM OF 2.5m HORIZONTALLY FROM OUTSIDE EDGE OF SEWER PIPE.

GEOTEXTILE CLOTH TO BE INSTALLED UNDER ALL CB AND CBMH GRATES AND TO REMAIN IN PLACE UNTIL PAVING IS COMPLETED

LEGEND	
---	SUBDIVISION BOUNDARY
---	PROPOSED RIGHT OF WAY
---	PROPOSED PROPERTY LINES
---	EDGE OF EXISTING PAVEMENT
---	EDGE OF EXISTING GRAVEL
---	PROPOSED SANITARY SEWER
---	EXISTING SANITARY SEWER
---	PROPOSED STORM SEWER
---	EXISTING STORM SEWER
---	PROPOSED SUBDRAIN
---	PROPOSED WATERMAIN
---	EXISTING WATERMAIN
---	PROPOSED SANITARY SERVICE
---	PROPOSED WATER SERVICE
---	EXISTING UNDERGROUND TV CABLE
---	EXISTING UNDERGROUND GAS LINE
---	EXISTING UNDERGROUND HYDRO CABLE
---	EXISTING UNDERGROUND TELEPHONE CABLE
○	PROPOSED SANITARY MANHOLE
○	EXISTING SANITARY MANHOLE
○	PROPOSED STORM MANHOLE
○	EXISTING STORM MANHOLE
○	PROPOSED CATCHBASIN MANHOLE
○	EXISTING CATCHBASIN MANHOLE
○	PROPOSED TWIN INLET CATCHBASIN MANHOLE
○	EXISTING TWIN INLET CATCHBASIN MANHOLE
○	PROPOSED CATCH BASIN
○	EXISTING CATCH BASIN
○	PROPOSED DITCH INLET CATCHBASIN
○	EXISTING DITCH INLET CATCHBASIN
○	PROPOSED REAR YARD INLET BASIN
○	EXISTING REAR YARD INLET BASIN
○	PROPOSED SAN. CLEANOUT (CAPPED WYE)
○	EXISTING SAN. CLEANOUT (CAPPED WYE)
○	PROPOSED CURB STOP VALVE
○	EXISTING CURB STOP VALVE
○	PROPOSED STORM SERVICE
○	EXISTING STORM SERVICE
○	PROPOSED HYDRANT SET
○	EXISTING HYDRANT SET
○	PROPOSED FIRE HYDRANT
○	EXISTING FIRE HYDRANT
○	PROPOSED CAP C/W THRUST BLOCK
○	EXISTING CAP C/W THRUST BLOCK
○	PROPOSED BLOWOFF
○	EXISTING BLOWOFF
○	EXISTING HYDRO GUY WIRE
○	EXISTING HYDRO POLE
○	EXISTING CABLE TV PEDESTAL
○	EXISTING TELEPHONE PEDESTAL
○	STANDARD IRON BAR
○	IRON BAR
○	EXISTING DECIDUOUS TREE
○	EXISTING CONIFEROUS TREE
○	EXISTING GAS MARKER
○	EXISTING WELL
○	BENCHMARK
○	BOREHOLE
○	PROPOSED ELEVATION
○	EXISTING ELEVATION
○	ASPHALT REMOVAL
○	PROPOSED GATE VALVE
○	EXISTING GATE VALVE
○	PROPOSED VERTICAL BEND

CAUTION:
THE POSITION OF POLE LINES, CONDUITS, WATERMAINS, SEWERS AND OTHER UNDERGROUND AND OVERGROUND UTILITIES AND STRUCTURES IS NOT NECESSARILY SHOWN ON THE DRAWINGS, AND, WHERE SHOWN, THE ACCURACY OF THE POSITION OF SUCH UTILITIES AND STRUCTURES IS NOT GUARANTEED. BEFORE STARTING WORK, THE CONTRACTOR SHALL INFORM THEMSELVES OF THE EXACT LOCATION OF ALL SUCH UTILITIES AND STRUCTURES, AND SHALL ASSUME ALL LIABILITY FOR DAMAGE TO THEM.

 - Notes
1. TOPOGRAPHICAL INFORMATION DERIVED FROM FIELD SURVEY BY COBIDE ENGINEERING INC. COMPLETED ON MARCH 09, 2026.
 2. PROPERTY BOUNDARY INFORMATION DERIVED FROM REGISTERED PLAN 762 COMPLETED BY VAN HARTEN LAND SURVEYORS - ENGINEERS ON DECEMBER 04, 2025.
 3. THIS DRAWING IS NOT TO BE USED FOR CONSTRUCTION PURPOSES UNTIL STAMPED 'ISSUED FOR CONSTRUCTION'.
 4. LOCATIONS OF INDIVIDUAL WATER AND SANITARY LATERALS SHOWN ARE APPROXIMATE AND EXACT LOCATIONS ARE TO BE DETERMINED PRIOR TO CONSTRUCTION.
 5. SANITARY SEWER TO BE PVC SDR 35.
 6. ALL JOINTS OF SANITARY MANHOLES TO BE CAULKED WITH MIN. 15mm BEAD, INSTALLED ON THE TOP OF JOINT OF EACH SECTION PRIOR TO ABOVE SECTION BEING INSTALLED. CAULKING TO BE SIKAFLEX 1A OR APPROVED EQUIVALENT.
 7. ALL CURB TO BE BARRIER CURB CONFORMING TO O.P.S.D. 600.110.
 8. COVER OVER WATERMAIN 2.00m MINIMUM AT ALL POINTS.
 9. ALL WATERMAINS SHALL BE 100mmØ PVC DR18.
 10. MAINTAIN 2.50m HORIZONTAL AND 0.50m VERTICAL SEPARATION BETWEEN SANITARY SEWERS AND WATERMAIN.
 11. ALL STORM CATCHBASINS TO HAVE A MINIMUM SLUMP OF 600mm AND ALL CATCHBASIN MANHOLES TO HAVE A MINIMUM SLUMP OF 300mm.
 12. ALL CONSTRUCTION TO BE COMPLETED TO TOWN OF HANOVER'S ENGINEERING STANDARDS.

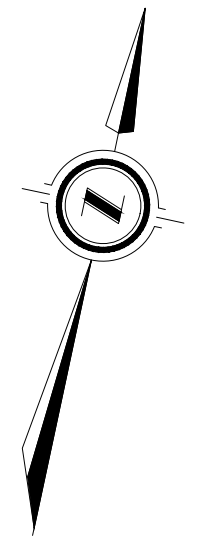

Benchmark Information	
BM1	NAIL IN HYDRO POLE ON WEST SIDE OF 10TH AVENUE ELEVATION 276.70m
BM2	TOP NUT OF FIRE HYDRANT AT THE NORTH-WEST CORNER OF 10TH AVENUE AND 9TH STREET INTERSECTION ELEVATION 276.71m

No.	DATE	DESCRIPTION	BY	APPD
3	AUG 13/26	ISSUED FOR TENDER	JHL	TLB
2	JUN 10/26	SECOND SUBMISSION	JHL	TLB
1	APR 10/26	FIRST SUBMISSION	JHL	TLB

REVISION / ISSUE	
Seal not valid unless signed and dated	


517 10th Street, Hanover, Ontario N4N 1R4
Telephone: (519) 506-5959
www.cobideeng.com

Title: 341 10TH STREET
TOWN OF HANOVER
HANOVER POLICE STATION
PROPOSED SITE PLAN

Client: +VG ARCHITECTS

Design: TLB	Scale: 1:200
Drawn: SEH/JHL	Approved:
Checked: TLB	
Date: MAR 2026	Design Engineer


Drawn No. 10048-C2

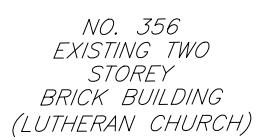

GEOTEXTILE CLOTH TO BE INSTALLED
UNDER ALL CB AND CBMH GRATES AND TO
REMAIN IN PLACE UNTIL PAVING IS
COMPLETED

- ### LEGEND


1. TOPOGRAPHICAL INFORMATION DERIVED FROM FIELD SURVEY BY COBIDE ENGINEERING INC. COMPLETED ON MARCH 09, 2026.
2. PROPERTY BOUNDARY INFORMATION DERIVED FROM REGISTERED PLAN 762 COMPLETED BY VAN HARTEN LAND SURVEYORS - ENGINEERS ON DECEMBER 04, 2026.
3. THIS DRAWING IS NOT TO BE USED FOR CONSTRUCTION PURPOSES UNTIL STAMPED ISSUED FOR CONSTRUCTION
4. LOCATIONS OF INDIVIDUAL WATER AND SANITARY LATERALS SHOWN ARE APPROXIMATE AND EXACT LOCATIONS ARE TO BE DETERMINED PRIOR TO CONSTRUCTION.
5. SANITARY SEWER TO BE PVC SDR 35.
6. ALL JOINTS OF SANITARY MANHOLES TO BE CAULKED WITH MIN. 15mm BEAD, INSTALLED ON THE TOP OF JOINT OF EACH SECTION PRIOR TO ABOVE SECTION BEING INSTALLED. CAULKING TO BE SIXKAFIX 140 APPROVED EQUIVALENT.
7. ALL CURB TO BE BARRIER CURB CONFORMING TO O.P.S.D. 600.110.
8. COVER OVER WATERMAIN 2.00m minimum. AT ALL POINTS.
9. ALL WATER MAINS TO BE 150mm PVC DRAIN.
10. MAINTAIN 2.50m HORIZONTAL AND 0.60m VERTICAL SEPARATION BETWEEN SANITARY SEWERS AND WATERMAIN.
11. ALL STORM CATCH-BASINS TO HAVE A MINIMUM SUMP OF 600mm AND ALL CATCH-BASINS TO HAVE A MINIMUM SUMP OF 300mm.
12. ALL CONSTRUCTION TO BE COMPLETED TO TOWN OF HANOVER'S ENGINEERING STANDARDS.

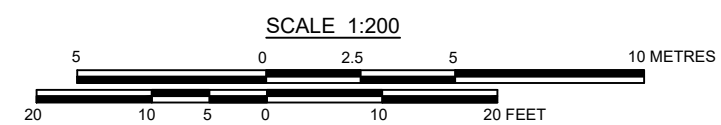


BM1	NAIL IN HYDRO POLE ON WEST SIDE OF 10TH AVENUE	
	ELEVATION	276.70m
BM2	TOP NUT OF FIRE HYDRANT AT THE NORTH-WEST	
	CORNER OF 10TH AVENUE AND 9TH STREET INTERSECTION	
	ELEVATION	276.71m

REVISION / ISSUE

Seal not valid unless signed and dated

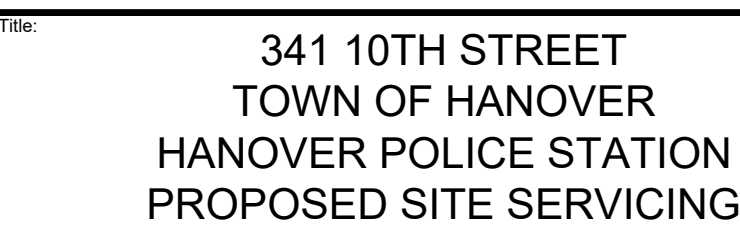


Design:	TLB	Scale:	1:200
Drawn:	SEH/JHL	Approved:	
Checked:	TLB		
Date:	MAR 2026		
DRAWING No.		10048-C3	
		Design Engineer	

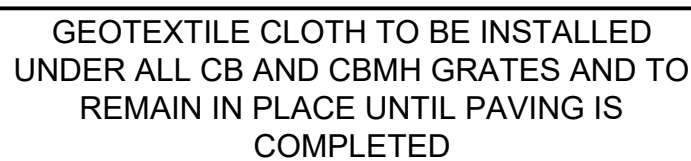


- CAUTION:** THE POSITION OF POLE LINES, CONDUITS, WATERMAINS, SEWERS AND OTHER UNDERGROUND AND OVERGROUND UTILITIES AND STRUCTURES IS NOT NECESSARILY SHOWN ON THE DRAWINGS, AND, WHERE SHOWN, THE ACCURACY OF THE POSITION OF SUCH UTILITIES AND STRUCTURES IS NOT GUARANTEED. BEFORE STARTING WORK, THE CONTRACTOR SHALL INFORM THEMSELF OF THE EXACT LOCATION OF ALL SUCH UTILITIES AND STRUCTURES, AND SHALL ASSUME ALL LIABILITY FOR DAMAGE TO THEM.


1. TOPOGRAPHICAL INFORMATION DERIVED FROM FIELD SURVEY BY COBIDE ENGINEERING INC. COMPLETED ON MARCH 09, 2026.
2. PROPERTY BOUNDARY INFORMATION DERIVED FROM REGISTERED PLAN 762 COMPLETED BY VAN HARTEN LAND SURVEYORS - ENGINEERS ON DECEMBER 04, 2025.
3. THIS DRAWING IS NOT TO BE USED FOR CONSTRUCTION PURPOSES UNTIL STAMPED ISSUED TO BE USED FOR CONSTRUCTION.
4. LOCATIONS OF INDIVIDUAL AND SANITARY LATERALS SHOWN ARE APPROXIMATE AND EXACT LOCATIONS ARE TO BE DETERMINED PRIOR TO CONSTRUCTION.
5. SANITARY SEWER TO BE PVC SDR 35.
6. ALL JOINTS OF SANITARY MANHOLES TO BE CAULKED WITH MIN. 15MM BEAD INSTALLED ON THE TOP OF JOINT OF EACH SECTION PRIOR TO ABOVE SECTION BEING INSTALLED. CAULKING TO BE SIKAFLEX 1+0 APPROVED EQUIVALENT.
7. ALL CURB TO BE BARRIER CURB CONFORMING TO O.P.S.D. 600.110.
8. COVER OVER WATERMAIN 2.0m MINIMUM AT ALL POINTS.
9. WATERMAINS 150mm TO 300mm TO BE 0.1% GRADE.
10. MAINTAIN 2.50m HORIZONTAL AND 1.50m VERTICAL SEPARATION BETWEEN SANITARY SEWERS AND WATERMAIN.
11. ALL STORM CATCHBASINS TO HAVE A MINIMUM SLUMP OF 800mm AND ALL CATCHBASINS TO HAVE A MINIMUM SLUMP OF 300mm.
12. ALL CONSTRUCTION TO BE COMPLETED TO TOWN OF HANOVER'S ENGINEERING STANDARDS.

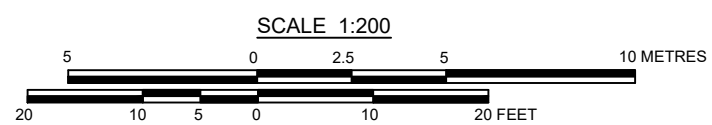

BM1	NAIL IN HYDRO POLE ON WEST SIDE OF 10TH AVENUE	
	ELEVATION	276.70m
BM2	TOP NUT OF FIRE HYDRANT AT THE NORTH-WEST CORNER OF 10TH AVENUE AND 9TH STREET INTERSECTION	
	ELEVATION	276.71m

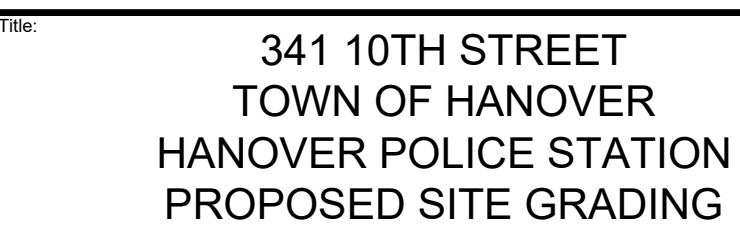Seal not valid unless signed and dated

Design Engineer

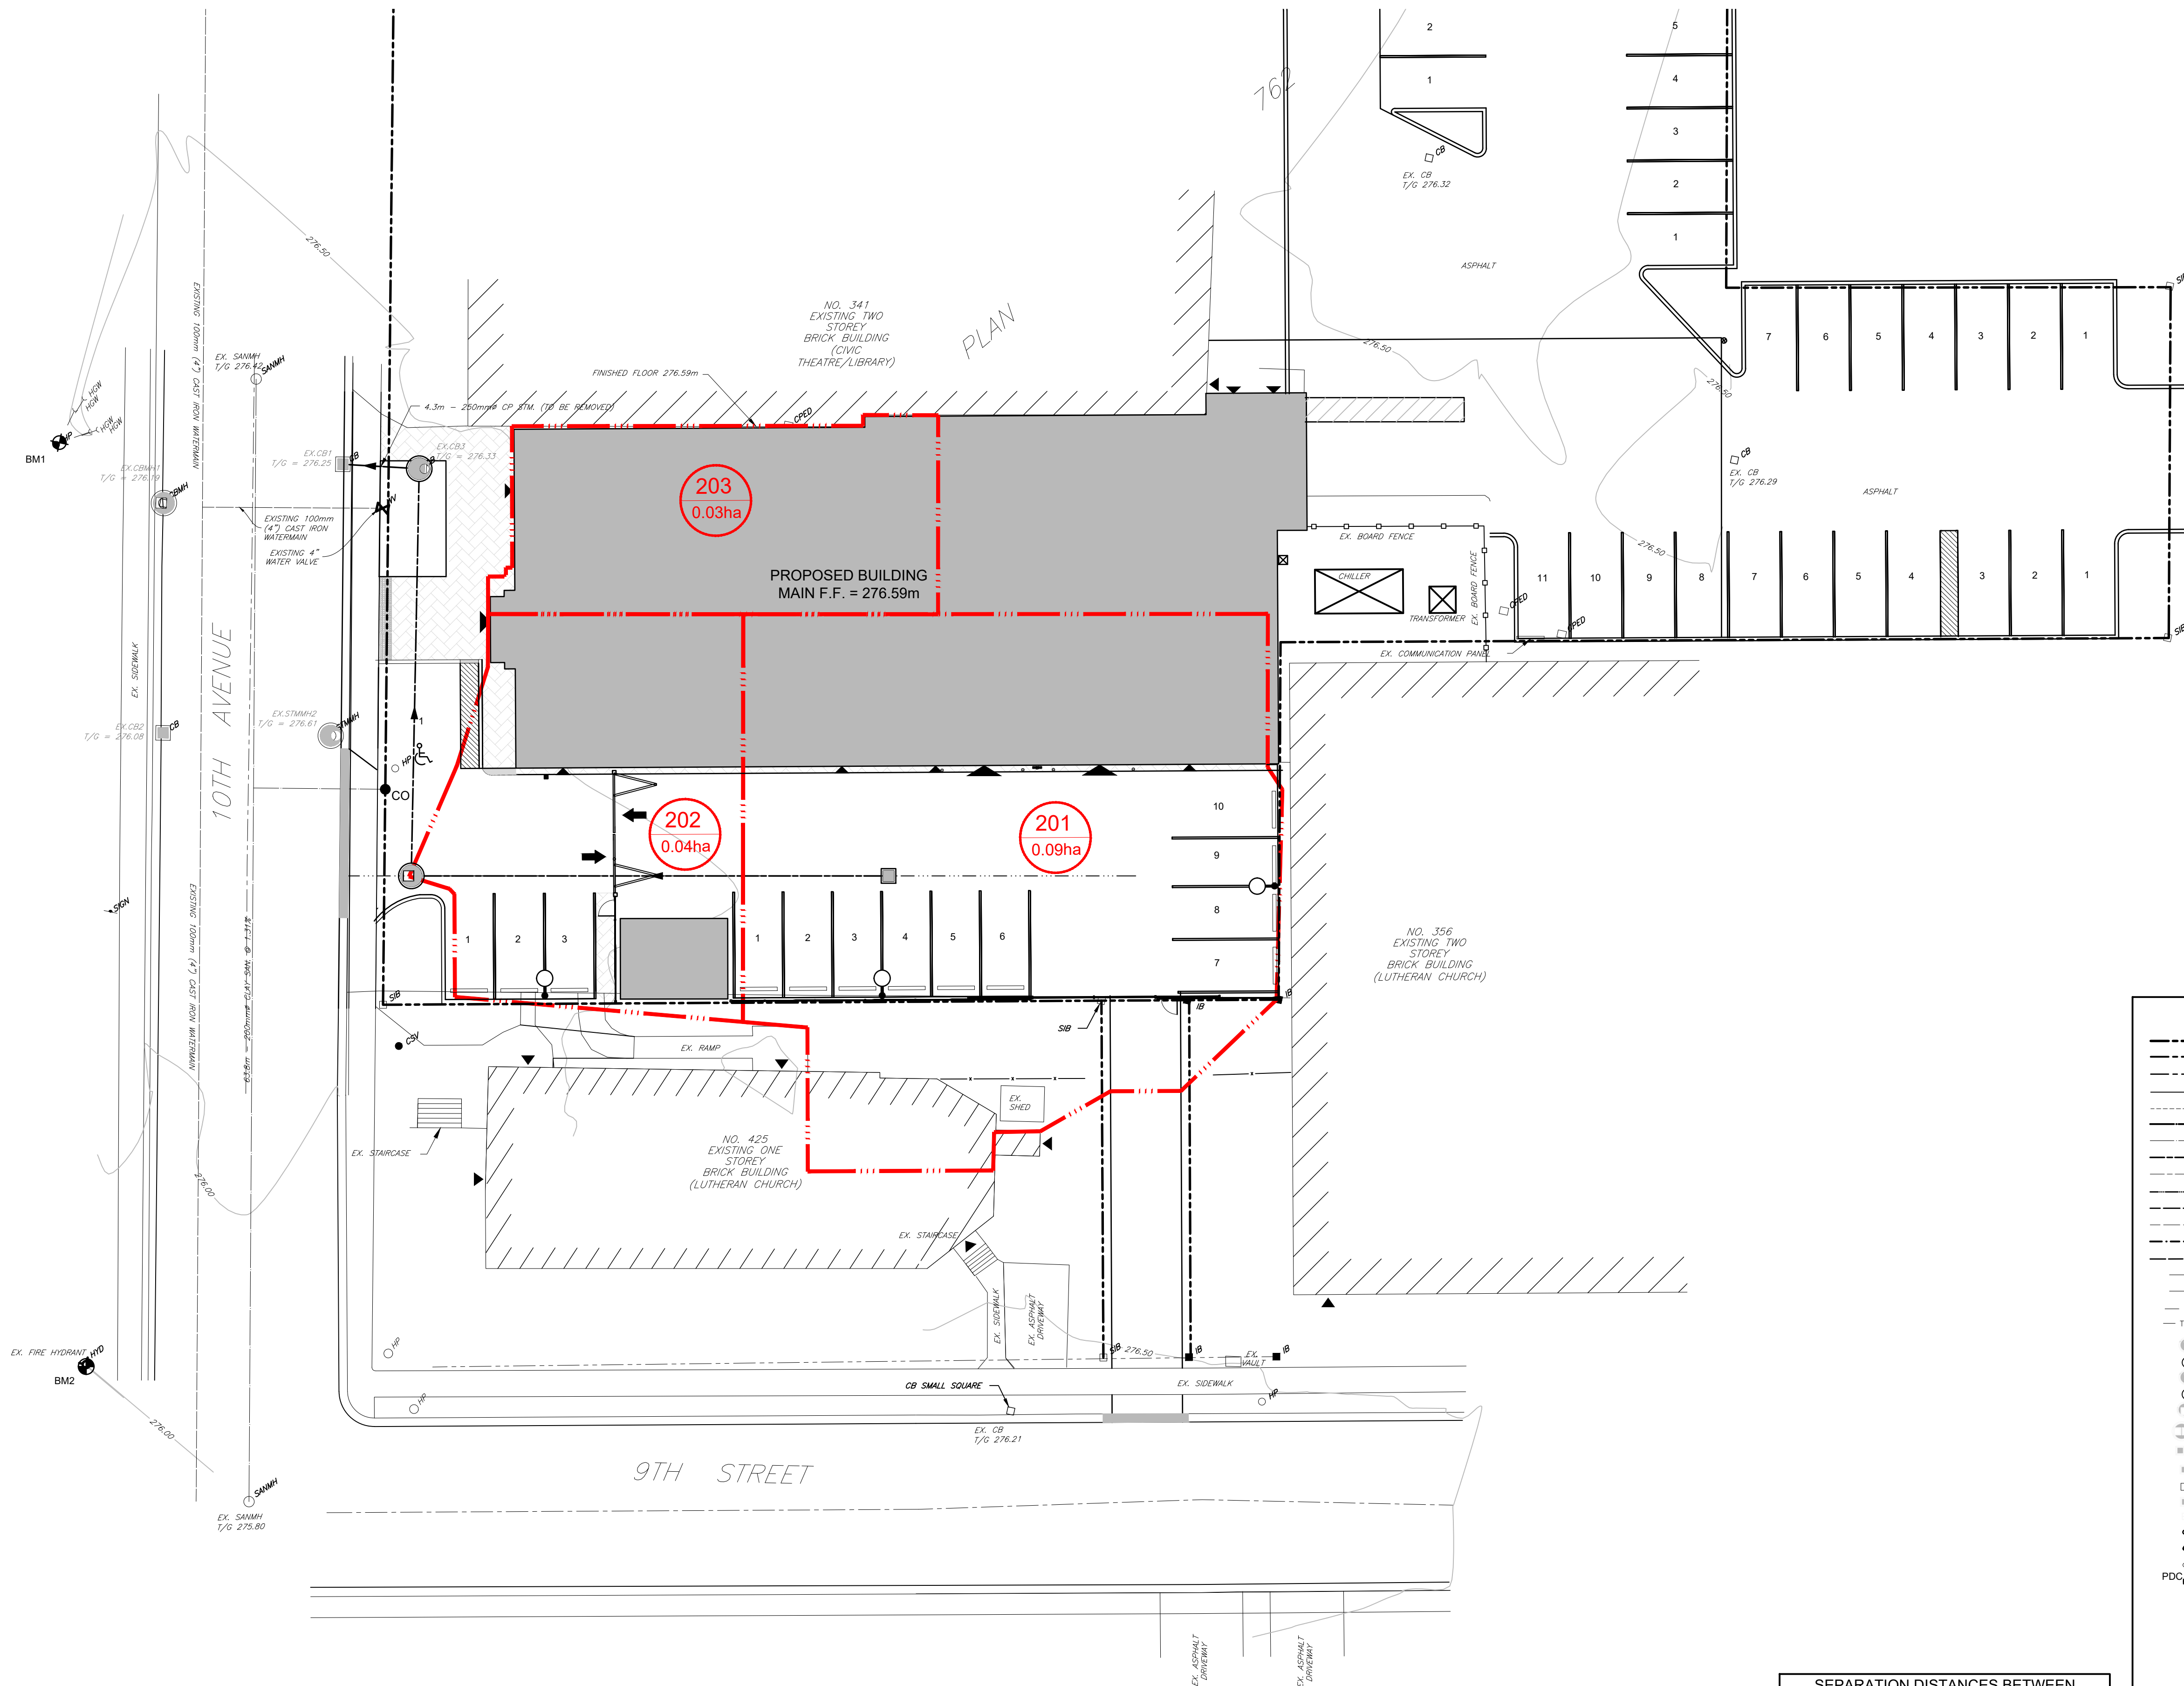


SEPARATION DISTANCES BETWEEN SEWERS/SEWER SERVICES AND WATERMAIN/WATER SERVICES SHALL BE AS PER MECP PROCEDURE F-6-1; IN GENERAL, 2.5m MINIMUM HORIZONTAL SEPARATION BETWEEN PARALLEL INSTALLATIONS AND 0.5m VERTICAL SEPARATION AT CROSSINGS WHERE THE WATERMAIN OR WATER SERVICE CROSSES UNDER THE SEWER/SERVICE AND PLACE WATER PIPE JOINTS A MINIMUM OF 2.5m HORIZONTALLY FROM OUTSIDE EDGE OF SEWER PIPE.

GEOTEXTILE CLOTH TO BE INSTALLED UNDER ALL CB AND CBMH GRATES AND TO REMAIN IN PLACE UNTIL PAVING IS COMPLETED

LEGEND	
---	SUBDIVISION BOUNDARY
---	PROPOSED RIGHT OF WAY
---	PROPOSED PROPERTY LINES
---	EDGE OF EXISTING PAVEMENT
---	EDGE OF EXISTING GRAVEL
---	PROPOSED SANITARY SEWER
---	EXISTING SANITARY SEWER
---	PROPOSED STORM SEWER
---	EXISTING STORM SEWER
---	PROPOSED SUBDRAIN
---	PROPOSED WATERMAIN
---	EXISTING WATERMAIN
---	PROPOSED SANITARY SERVICE
---	PROPOSED WATER SERVICE
---	EXISTING UNDERGROUND TV CABLE
---	EXISTING UNDERGROUND GAS LINE
---	EXISTING UNDERGROUND HYDRO CABLE
---	EXISTING UNDERGROUND TELEPHONE CABLE
○	PROPOSED SANITARY MANHOLE
○	EXISTING SANITARY MANHOLE
○	PROPOSED STORM MANHOLE
○	EXISTING STORM MANHOLE
○	PROPOSED CATCHBASIN MANHOLE
○	EXISTING CATCHBASIN MANHOLE
○	PROPOSED TWIN INLET CATCHBASIN MANHOLE
○	EXISTING TWIN INLET CATCHBASIN
○	PROPOSED CATCH BASIN
○	EXISTING CATCH BASIN
○	PROPOSED DITCH INLET CATCHBASIN
○	EXISTING DITCH INLET CATCHBASIN
○	PROPOSED REAR YARD INLET BASIN
○	EXISTING REAR YARD INLET BASIN
○	PROPOSED SAN. CLEANOUT (CAPPED WYE)
○	EXISTING SAN. CLEANOUT (CAPPED WYE)
○	PROPOSED CURB STOP VALVE
○	EXISTING CURB STOP VALVE
○	PROPOSED STORM SERVICE
○	EXISTING STORM SERVICE
○	PROPOSED HYDRANT SET
○	EXISTING HYDRANT SET
○	PROPOSED FIRE HYDRANT
○	EXISTING FIRE HYDRANT
○	PROPOSED CAP C/W THRUST BLOCK
○	EXISTING CAP C/W THRUST BLOCK
○	PROPOSED BLOWOFF
○	EXISTING BLOWOFF
○	EXISTING HYDRO GUY WIRE
○	EXISTING HYDRO POLE
○	EXISTING CABLE TV PEDESTAL
○	EXISTING TELEPHONE PEDESTAL
○	STANDARD IRON BAR
○	IRON BAR
○	EXISTING DECIDUOUS TREE
○	EXISTING CONIFEROUS TREE
○	EXISTING GAS MARKER
○	EXISTING WELL
○	BENCHMARK
○	BOREHOLE
○	PROPOSED ELEVATION
○	EXISTING ELEVATION
○	ASPHALT REMOVAL
○	PROPOSED GATE VALVE
○	EXISTING GATE VALVE
○	PROPOSED VERTICAL BEND

CAUTION:
THE POSITION OF POLE LINES, CONDUITS, WATERMAINS, SEWERS AND OTHER UNDERGROUND AND OVERGROUND UTILITIES AND STRUCTURES IS NOT NECESSARILY SHOWN ON THE DRAWINGS, AND, WHERE SHOWN, THE ACCURACY OF THE POSITION OF SUCH UTILITIES AND STRUCTURES IS NOT GUARANTEED. BEFORE STARTING WORK, THE CONTRACTOR SHALL INFORM THEMSELVES OF THE EXACT LOCATION OF ALL SUCH UTILITIES AND STRUCTURES, AND SHALL ASSUME ALL LIABILITY FOR DAMAGE TO THEM.


- Notes
1. TOPOGRAPHICAL INFORMATION DERIVED FROM FIELD SURVEY BY COBIDE ENGINEERING INC. COMPLETED ON MARCH 09, 2026.
 2. PROPERTY BOUNDARY INFORMATION DERIVED FROM REGISTERED PLAN 762 COMPLETED BY VAN HARTEN LAND SURVEYORS - ENGINEERS ON DECEMBER 04, 2025.
 3. THIS DRAWING IS NOT TO BE USED FOR CONSTRUCTION PURPOSES UNTIL STAMPED 'ISSUED FOR CONSTRUCTION'.
 4. LOCATIONS OF INDIVIDUAL WATER AND SANITARY LATERALS SHOWN ARE APPROXIMATE AND EXACT LOCATIONS ARE TO BE DETERMINED PRIOR TO CONSTRUCTION.
 5. SANITARY SEWER TO BE PVC SDR 35.
 6. ALL JOINTS OF SANITARY MANHOLES TO BE CAULKED WITH MIN. 15mm BEAD, INSTALLED ON THE TOP OF JOINT OF EACH SECTION PRIOR TO ABOVE SECTION BEING INSTALLED. CAULKING TO BE SIKAFLEX 1A OR APPROVED EQUIVALENT.
 7. ALL CURB TO BE BARRIER CURB CONFORMING TO O.P.S.D. 600.110.
 8. COVER OVER WATERMAIN 2.00m MINIMUM AT ALL POINTS.
 9. ALL WATERMAINS SHALL BE 100mmØ PVC DR18.
 10. MAINTAIN 2.50m HORIZONTAL AND 0.50m VERTICAL SEPARATION BETWEEN SANITARY SEWERS AND WATERMAIN.
 11. ALL STORM CATCHBASINS TO HAVE A MINIMUM SLUMP OF 600mm AND ALL CATCHBASIN MANHOLES TO HAVE A MINIMUM SLUMP OF 300mm.
 12. ALL CONSTRUCTION TO BE COMPLETED TO TOWN OF HANOVER'S ENGINEERING STANDARDS.

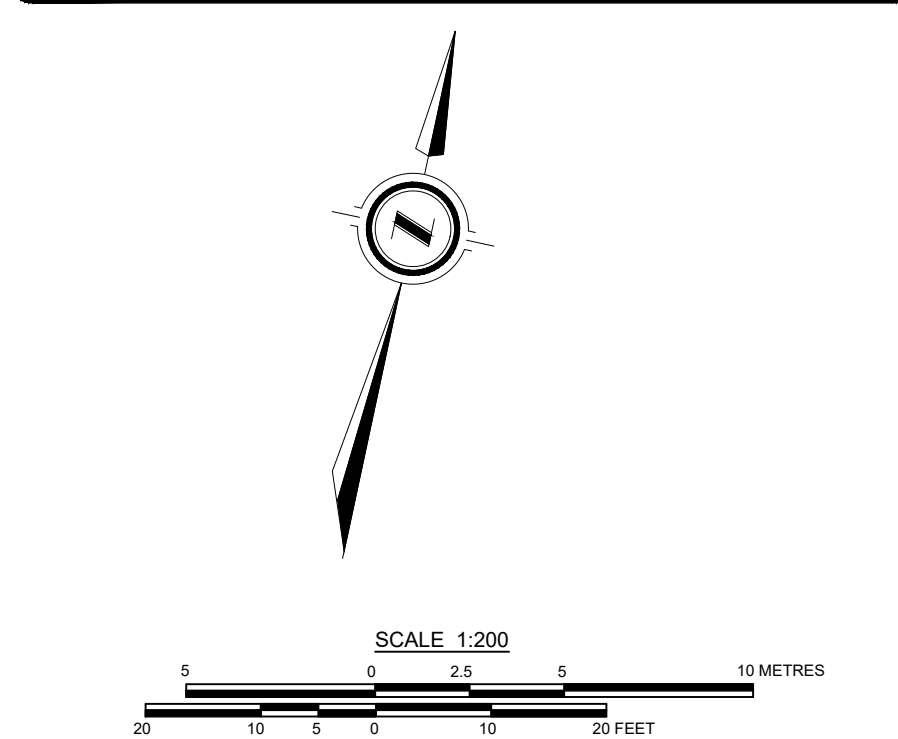

Benchmark Information	
BM1	NAIL IN HYDRO POLE ON WEST SIDE OF 10TH AVENUE ELEVATION 276.70m
BM2	TOP NUT OF FIRE HYDRANT AT THE NORTH-WEST CORNER OF 10TH AVENUE AND 9TH STREET INTERSECTION ELEVATION 276.71m

No.	DATE	DESCRIPTION	BY	APPD
3	AUG 13/26	ISSUED FOR TENDER	JHL	TLB
2	JUN 10/26	SECOND SUBMISSION	JHL	TLB
1	APR 10/26	FIRST SUBMISSION	JHL	TLB

REVISION / ISSUE	
Seal not valid unless signed and dated	

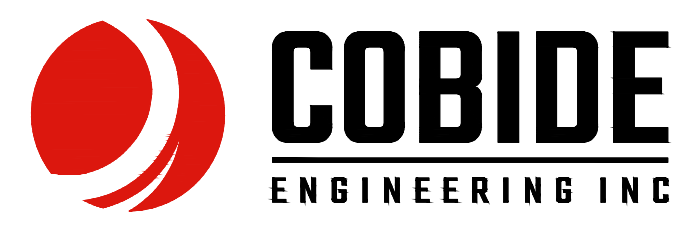






517 10th Street, Hanover, Ontario N4N 1R4
Telephone: (519) 506-5959
www.cobideeng.com

Title: 341 10TH STREET
TOWN OF HANOVER
HANOVER POLICE STATION
STORM SEWER CATCHMENT AREAS



Client: +VG ARCHITECTS



Design: TLB	Scale: 1:200
Drawn: SEH/JHL	Approved:
Checked: TLB	
Date: MAR 2026	Design Engineer










DRAWING No. 10048-C5

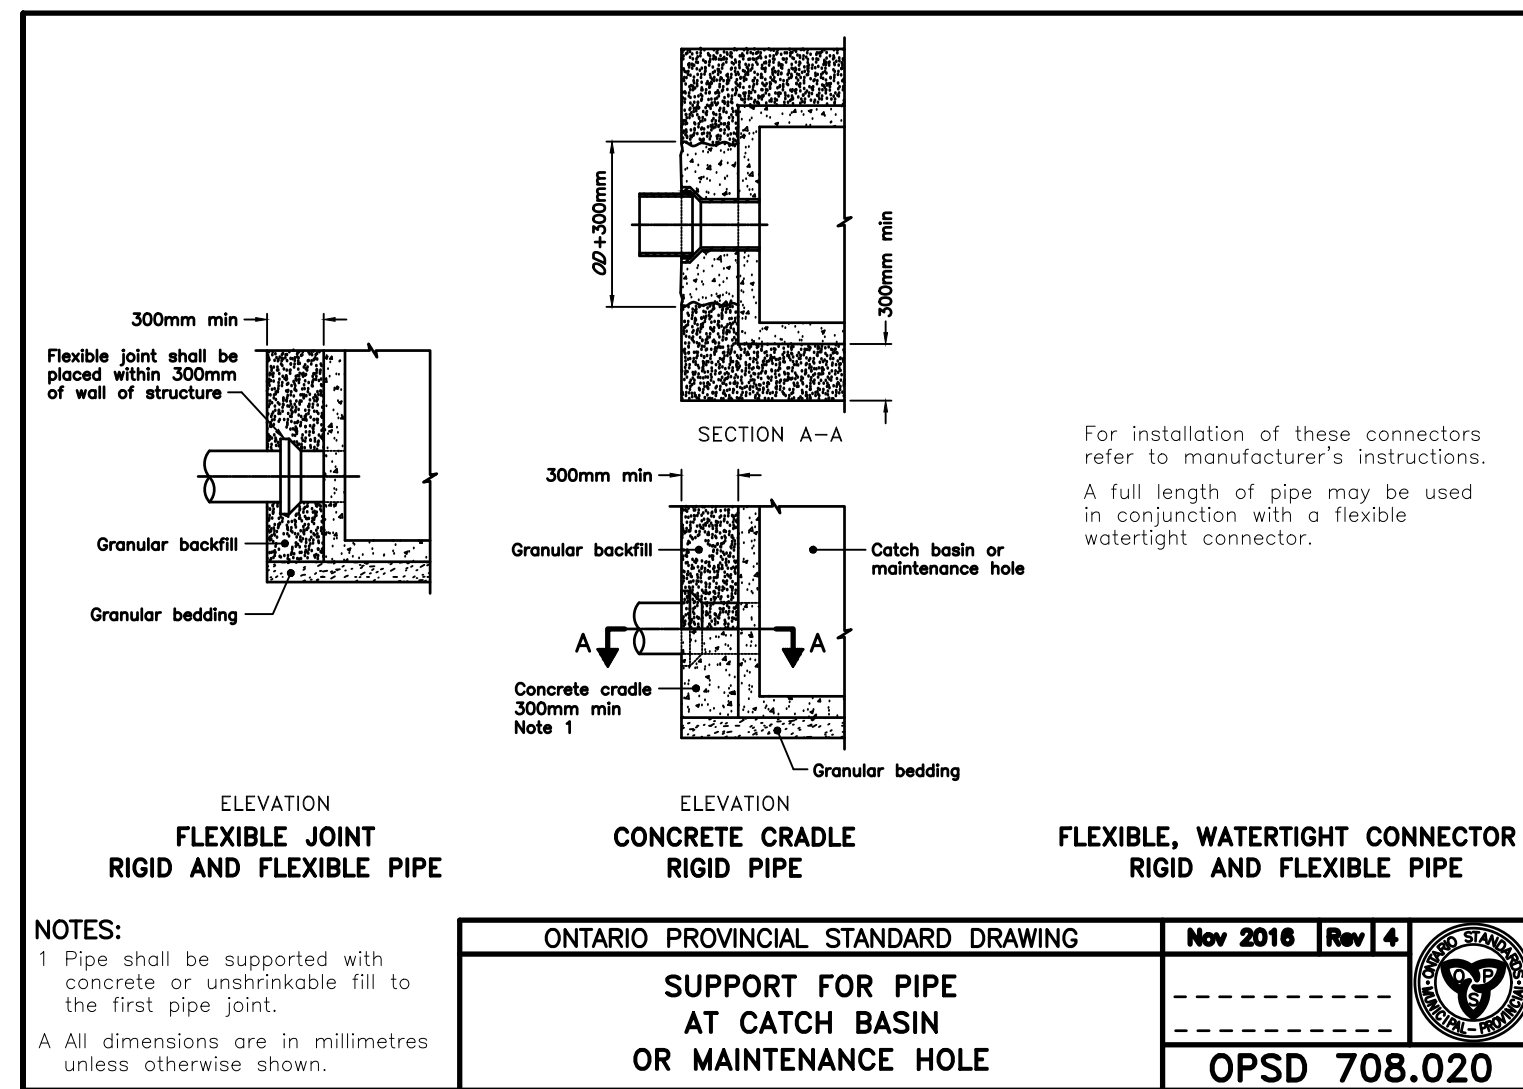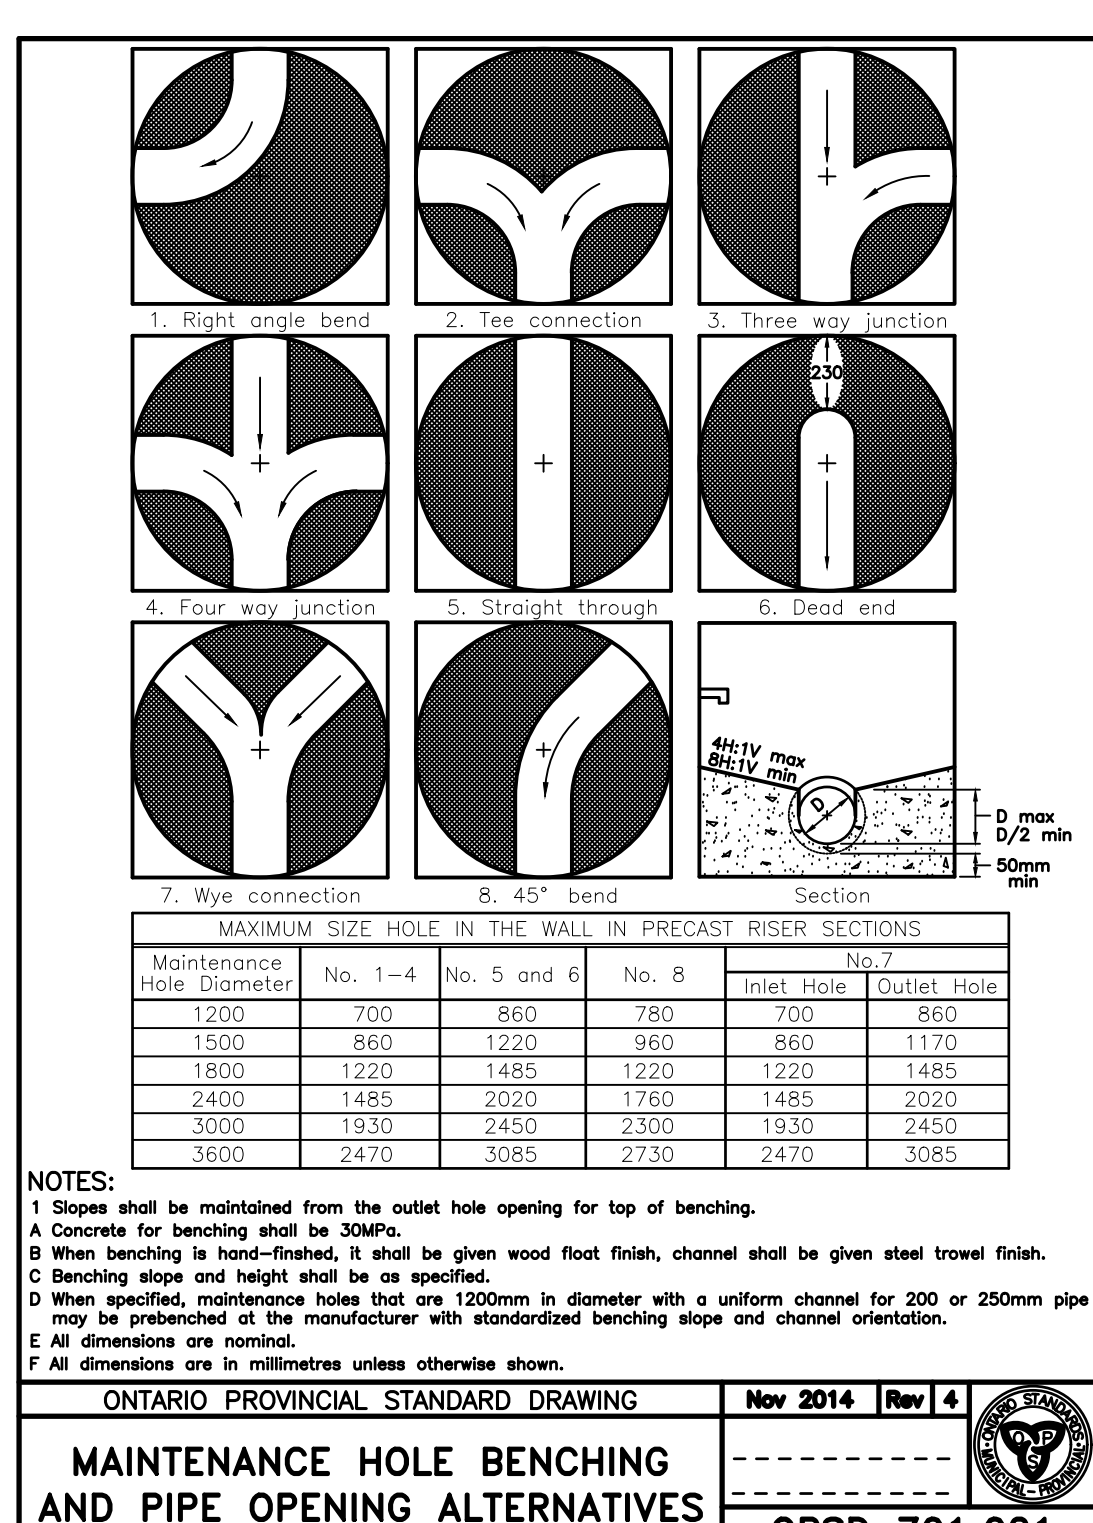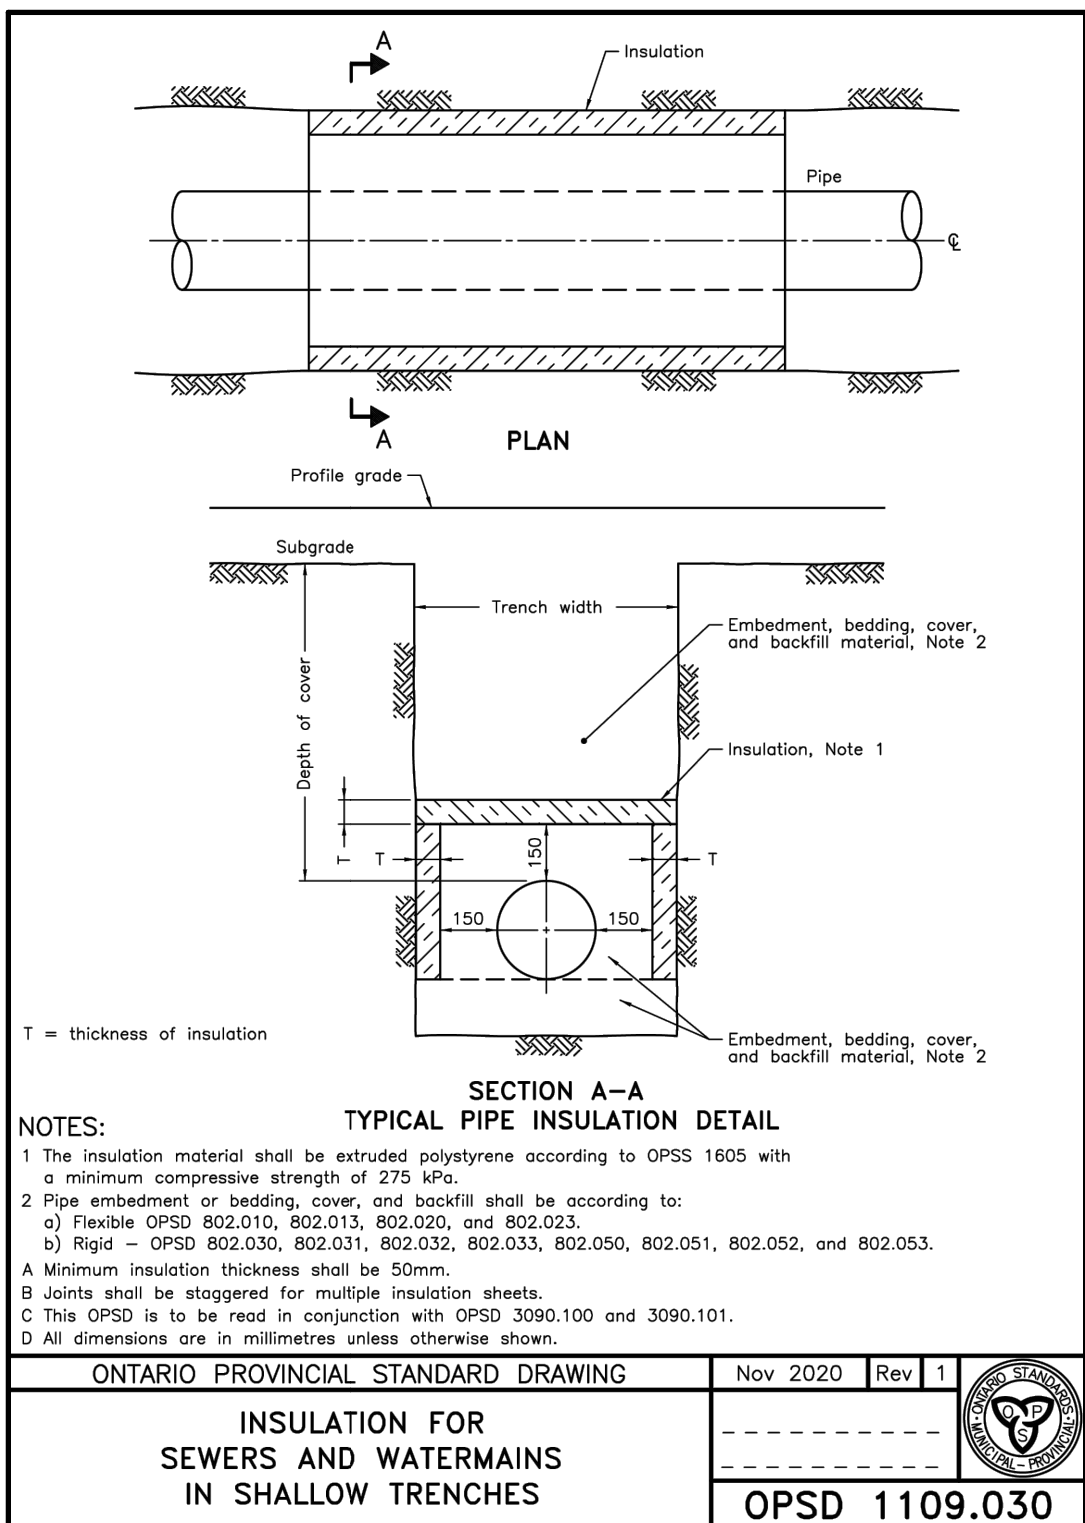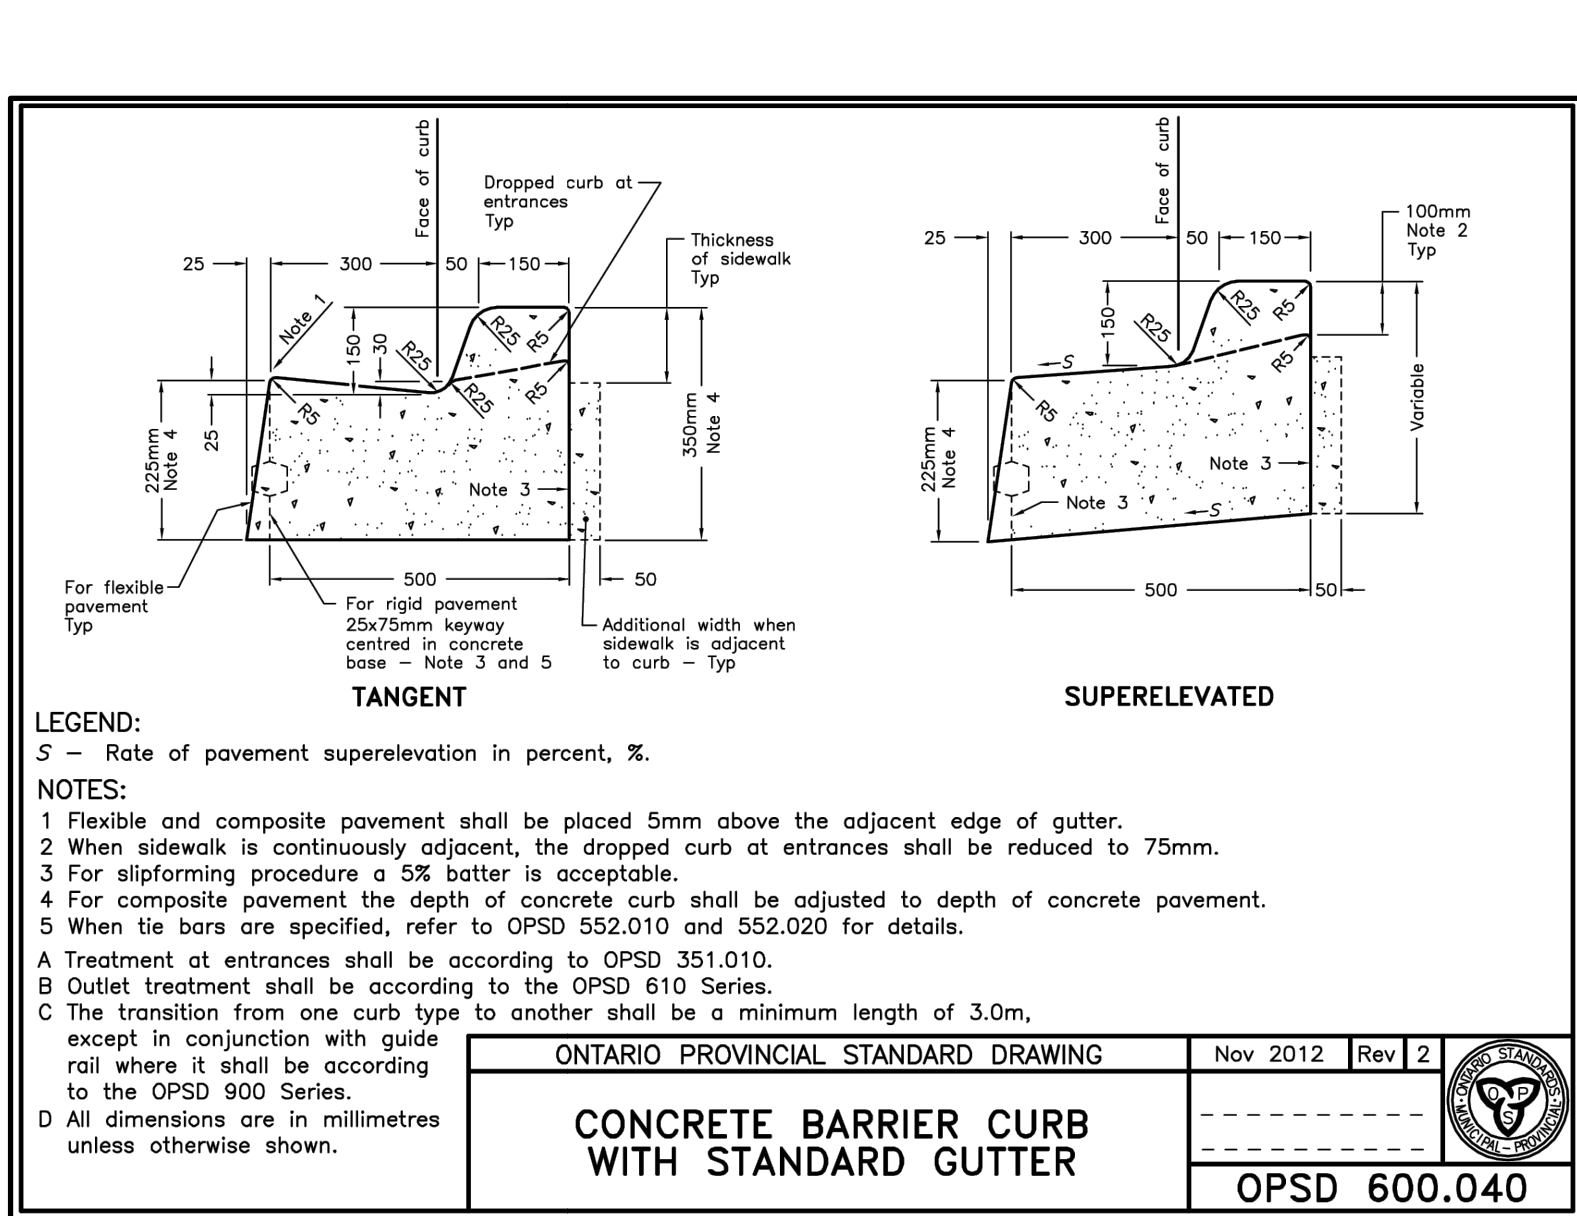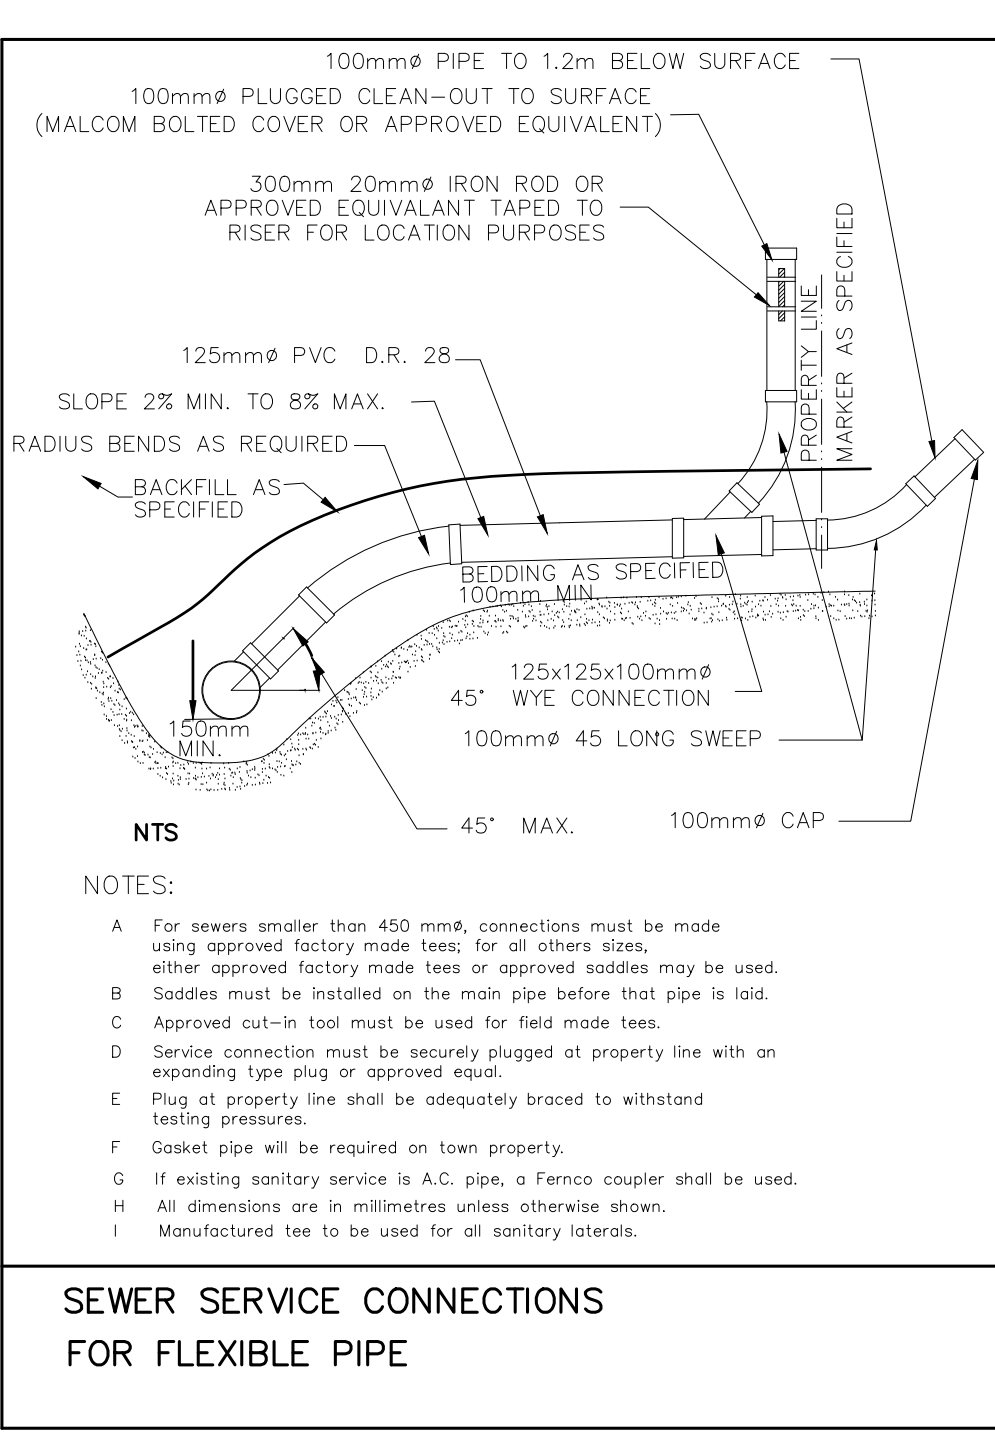

3	AUG 13/26	ISSUED FOR TENDER	JHL	TLB	
2	JUN 10/26	SECOND SUBMISSION	JHL	TLB	
1	APR 10/26	FIRST SUBMISSION	JHL	TLB	
No.	DATE	DESCRIPTION	BY	APPD	

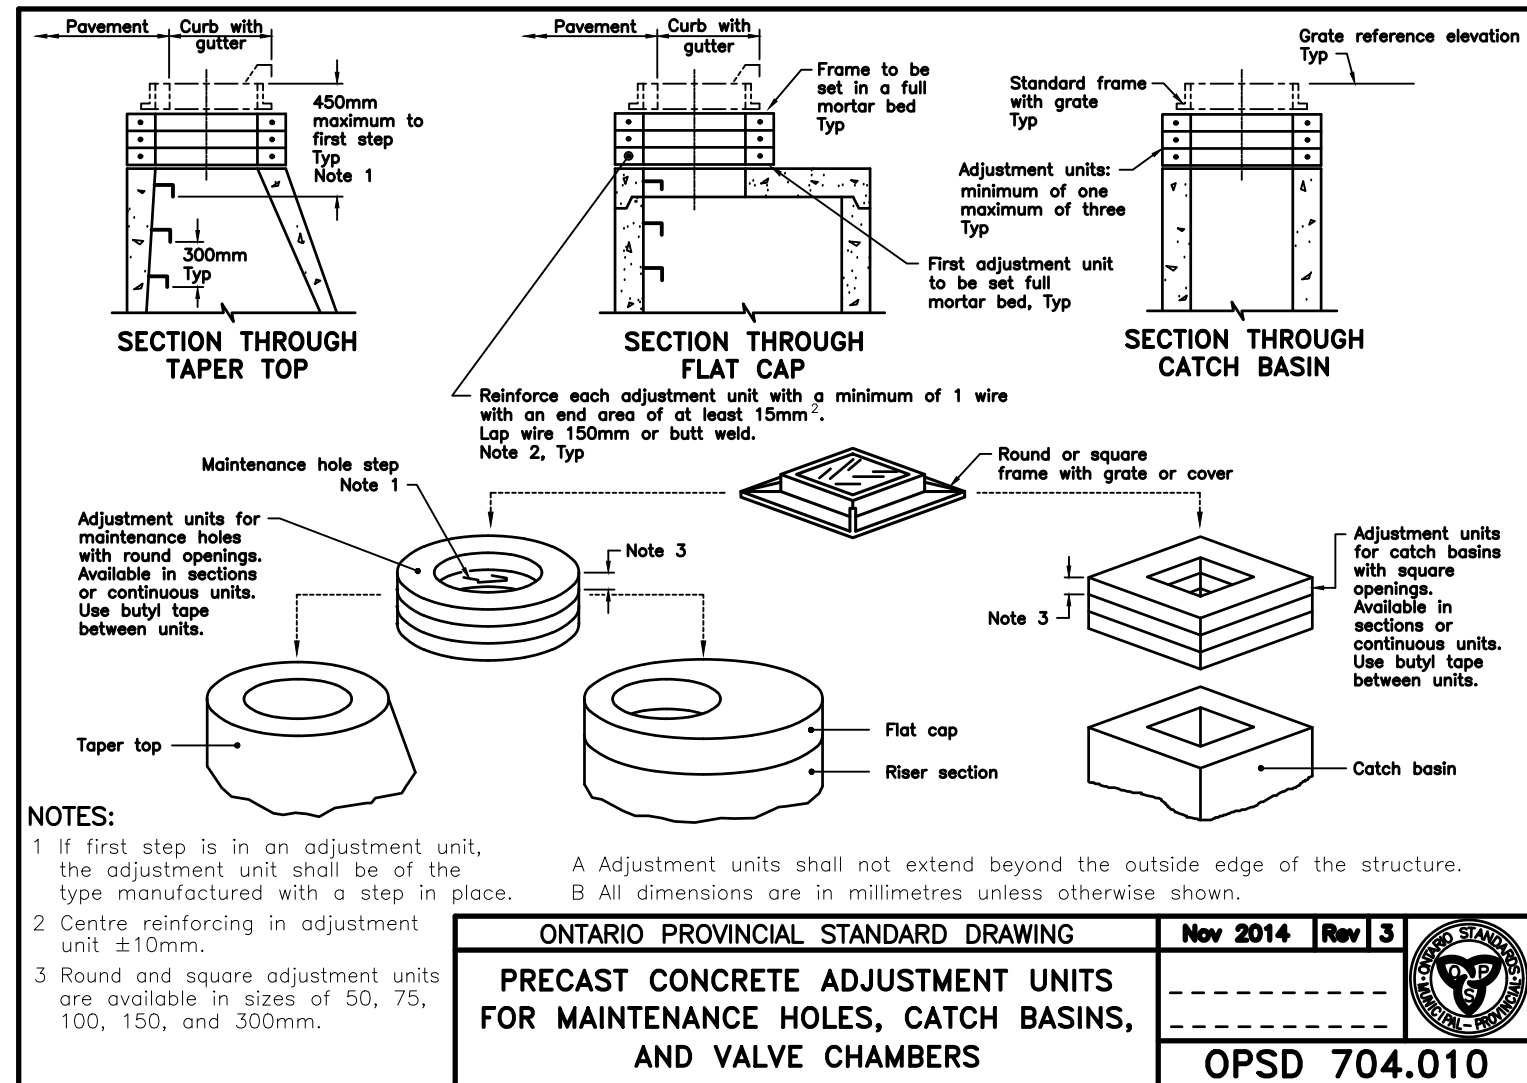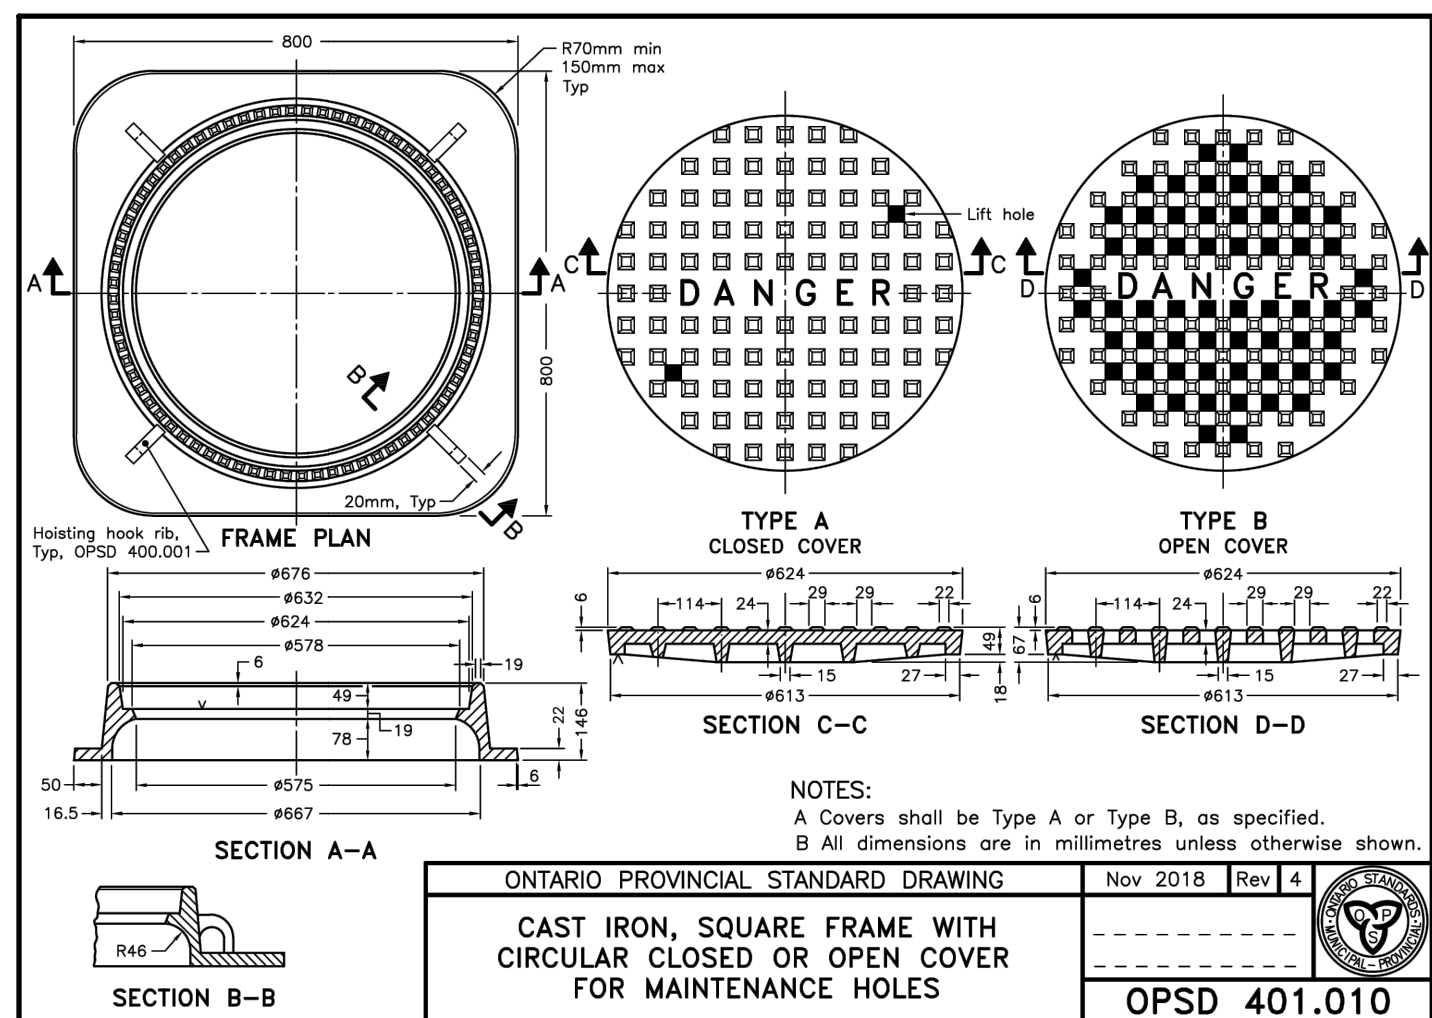

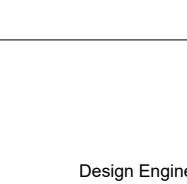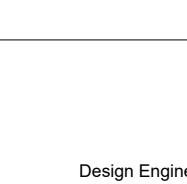
 COBIDE ENGINEERING INC	
517 10th Street, Hanover, Ontario N4N 1R4 Telephone: (519) 506-5959 www.cobideeng.com	
Title: 341 10TH STREET TOWN OF HANOVER HANOVER POLICE STATION DETAILS 1	
Client: +VG ARCHITECTS	
Design: TLB	Scale: -
Drawn: SEH/JHL	Approved: 
Checked: TLB	
Date: MAR 2026	
DRAWING No. 10048-DET1	
Design Engineer 	

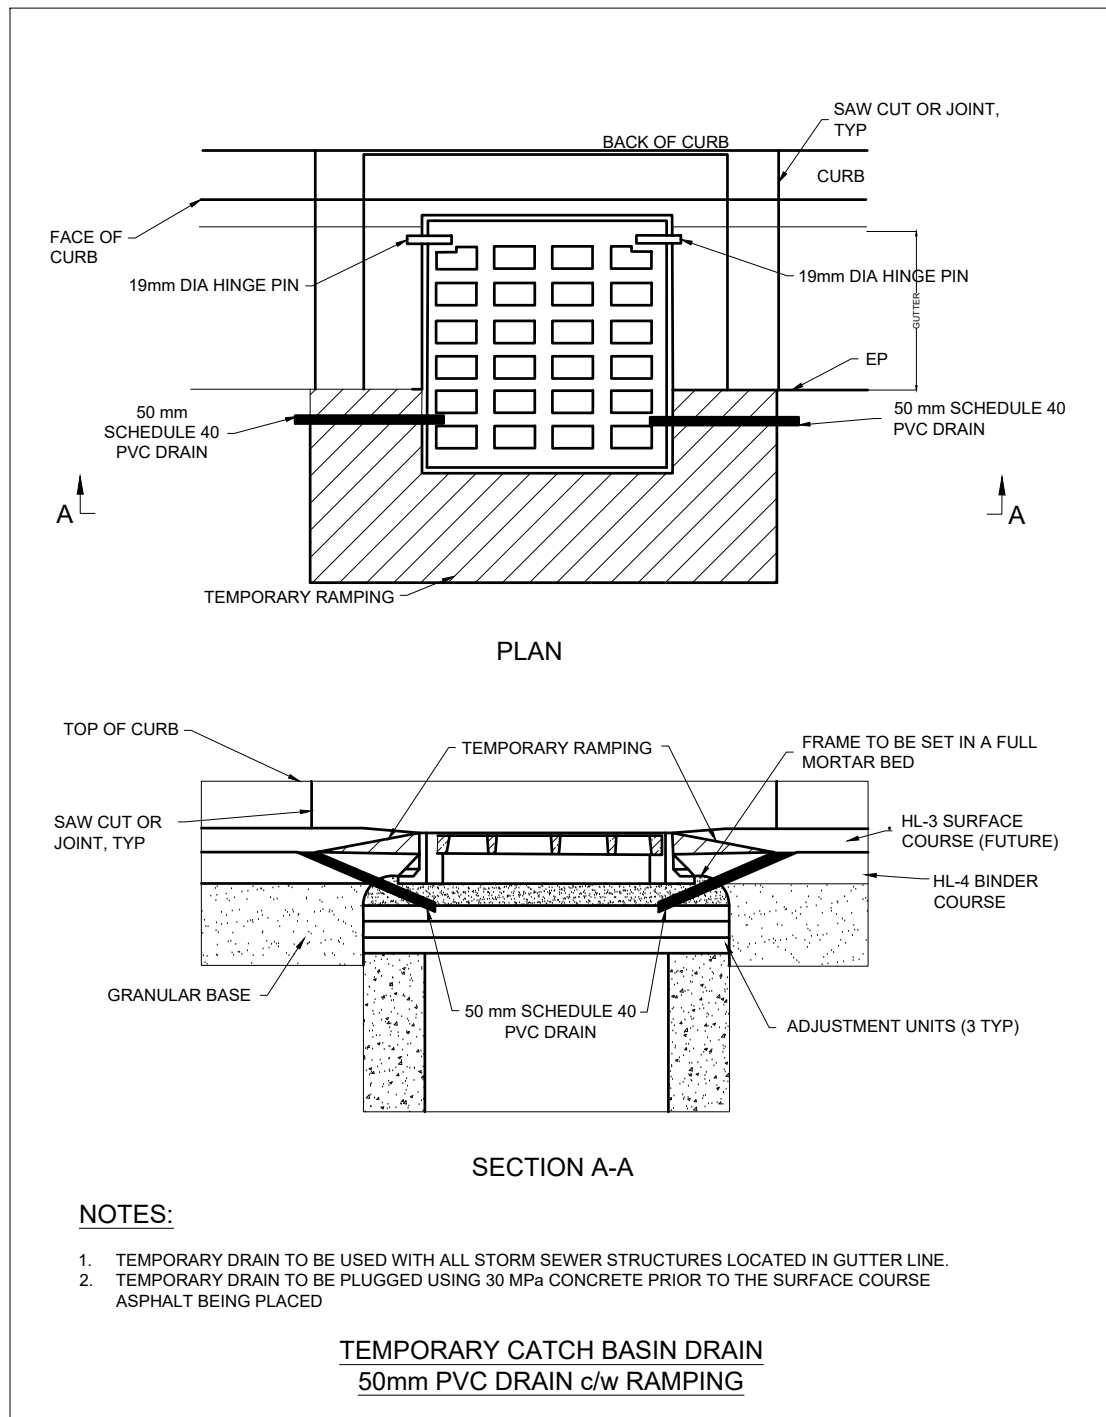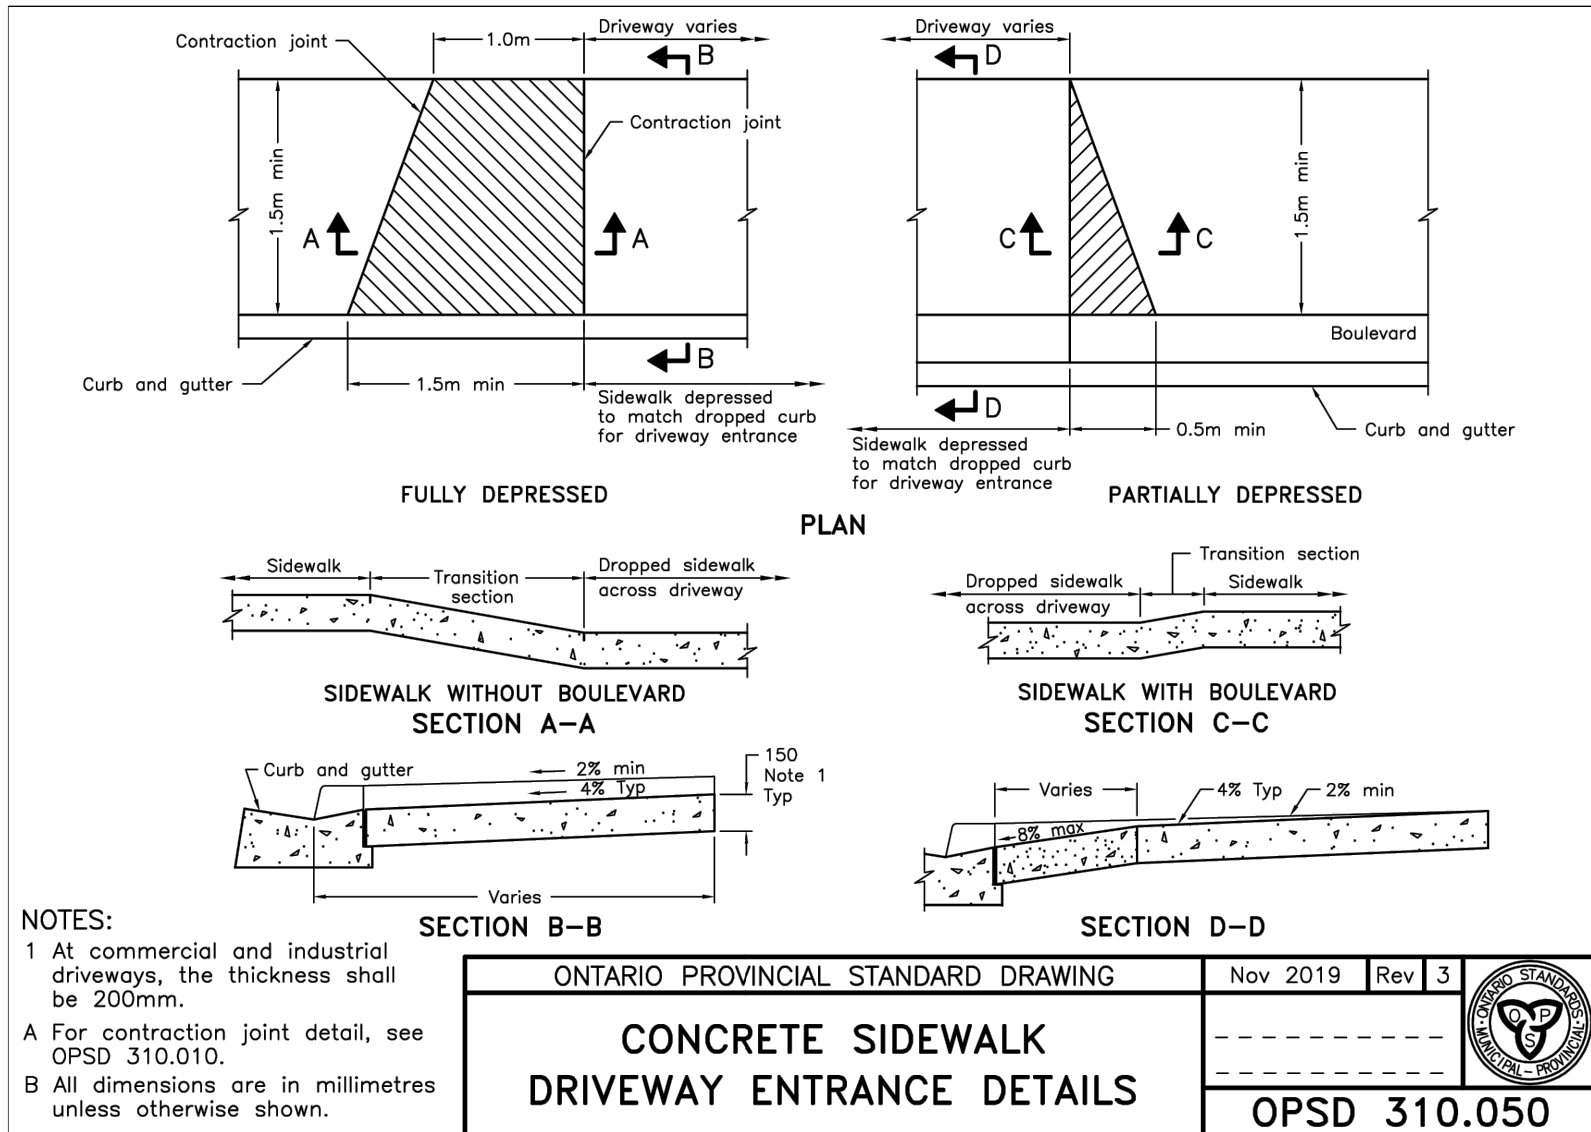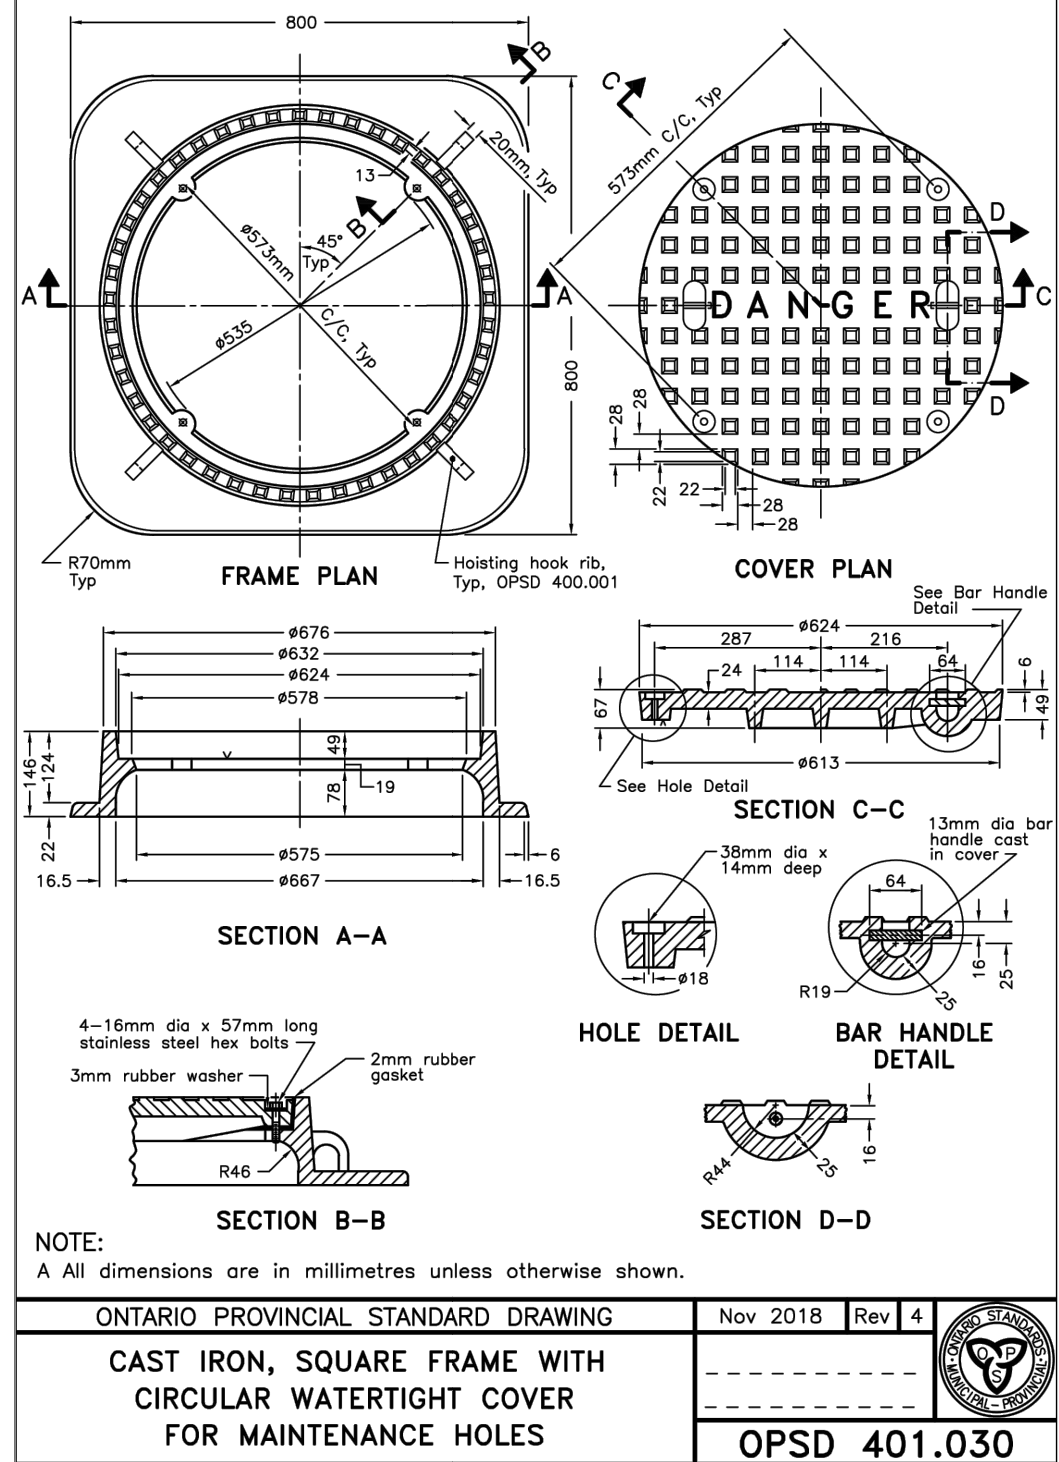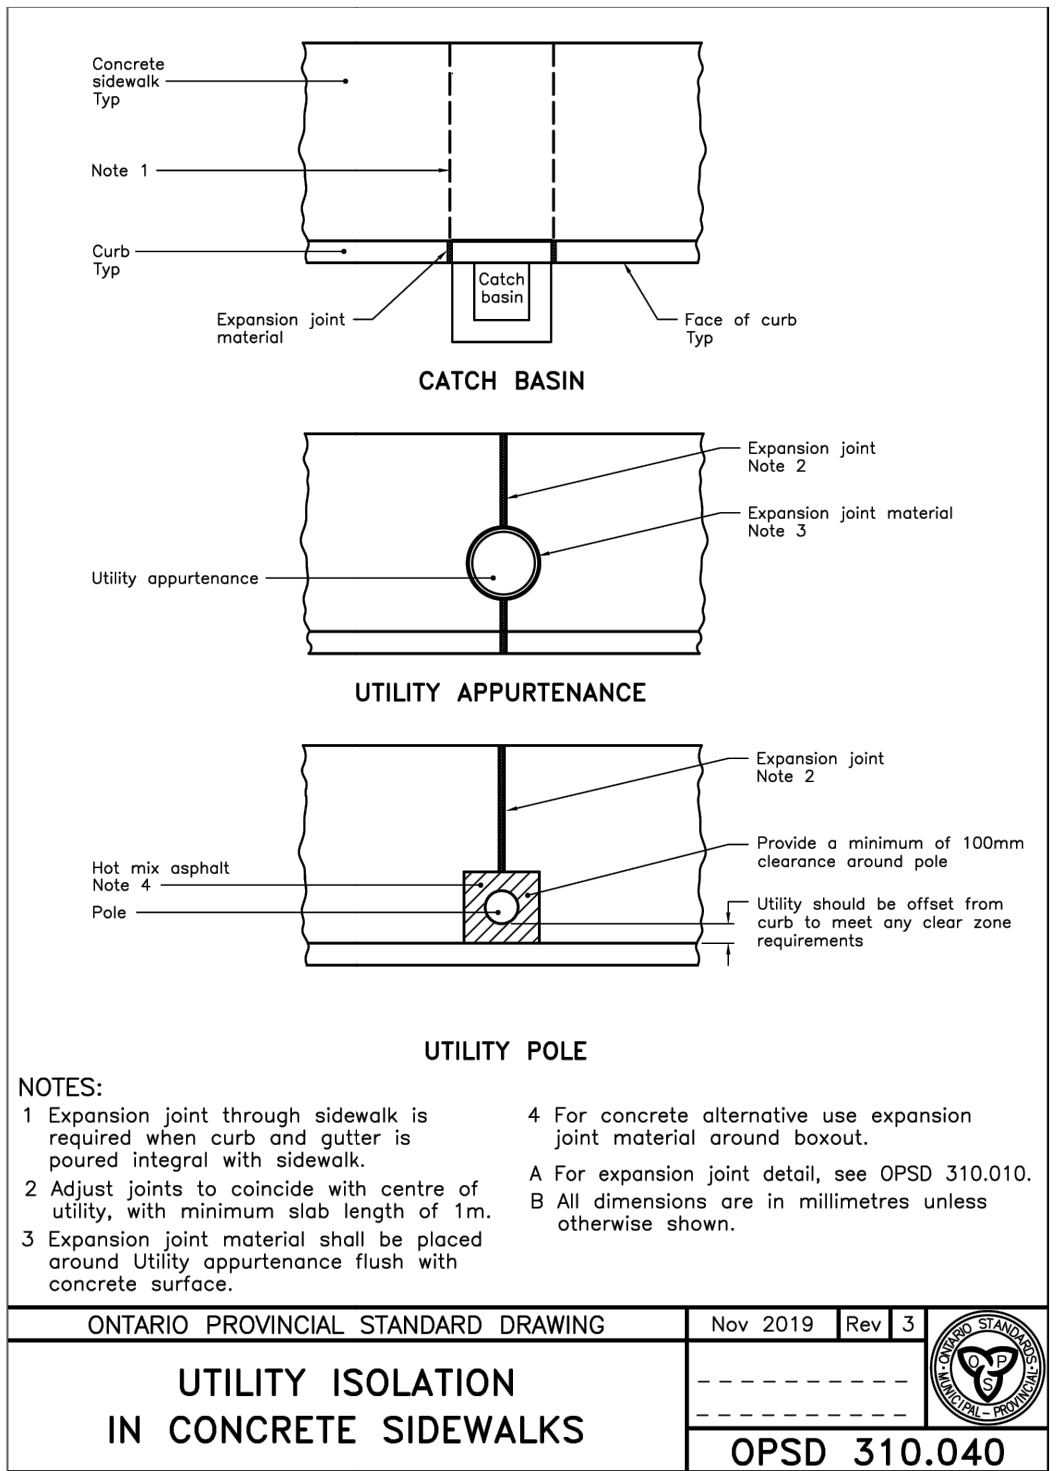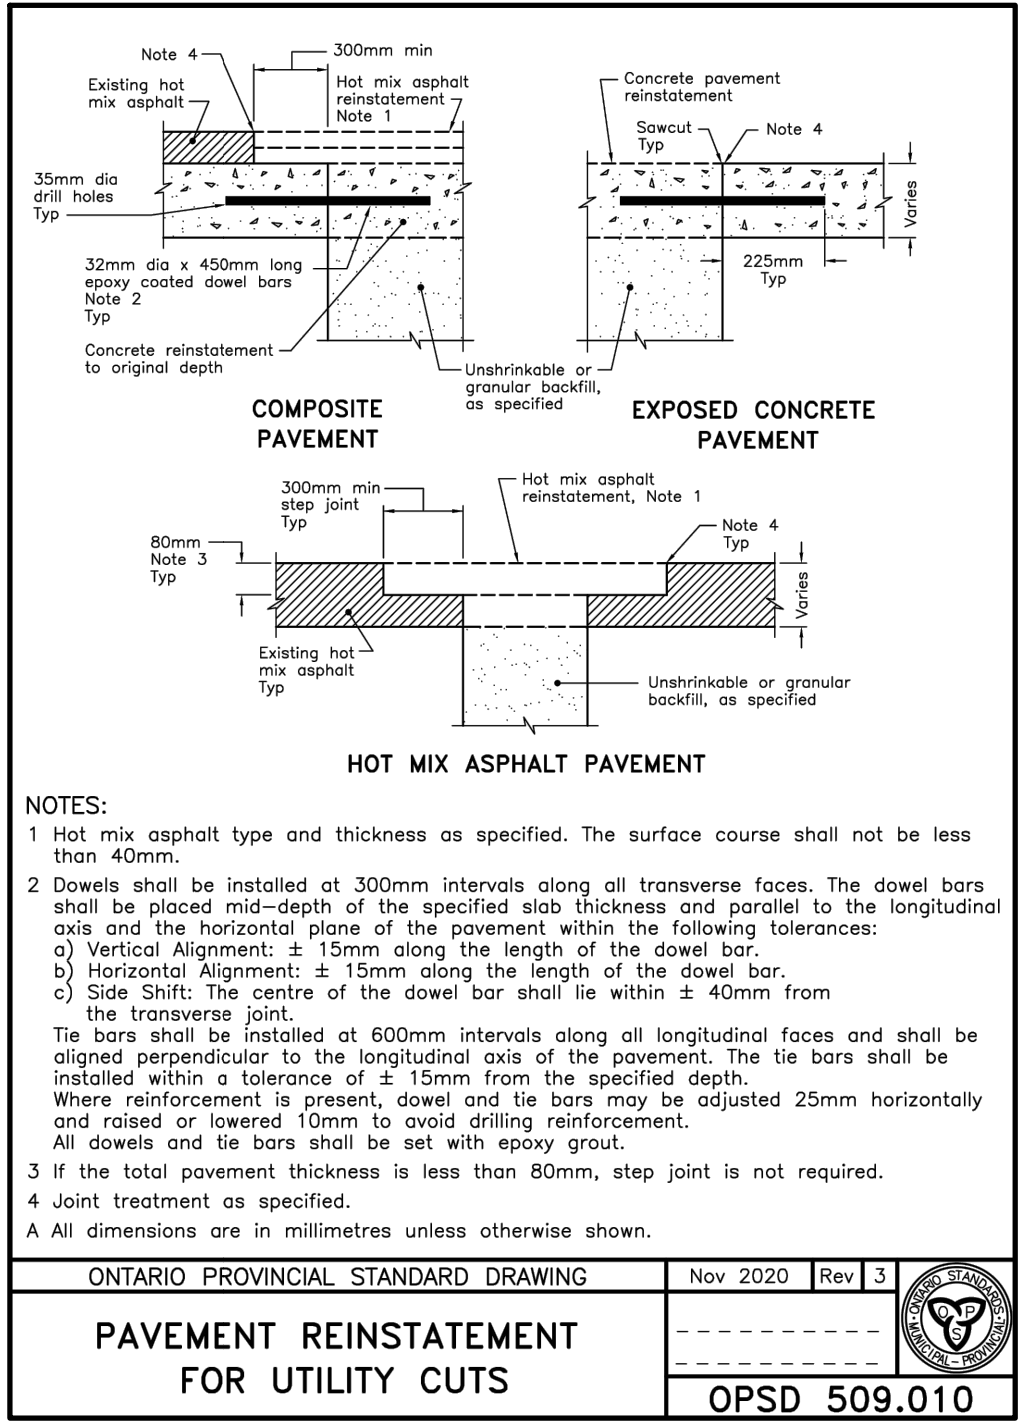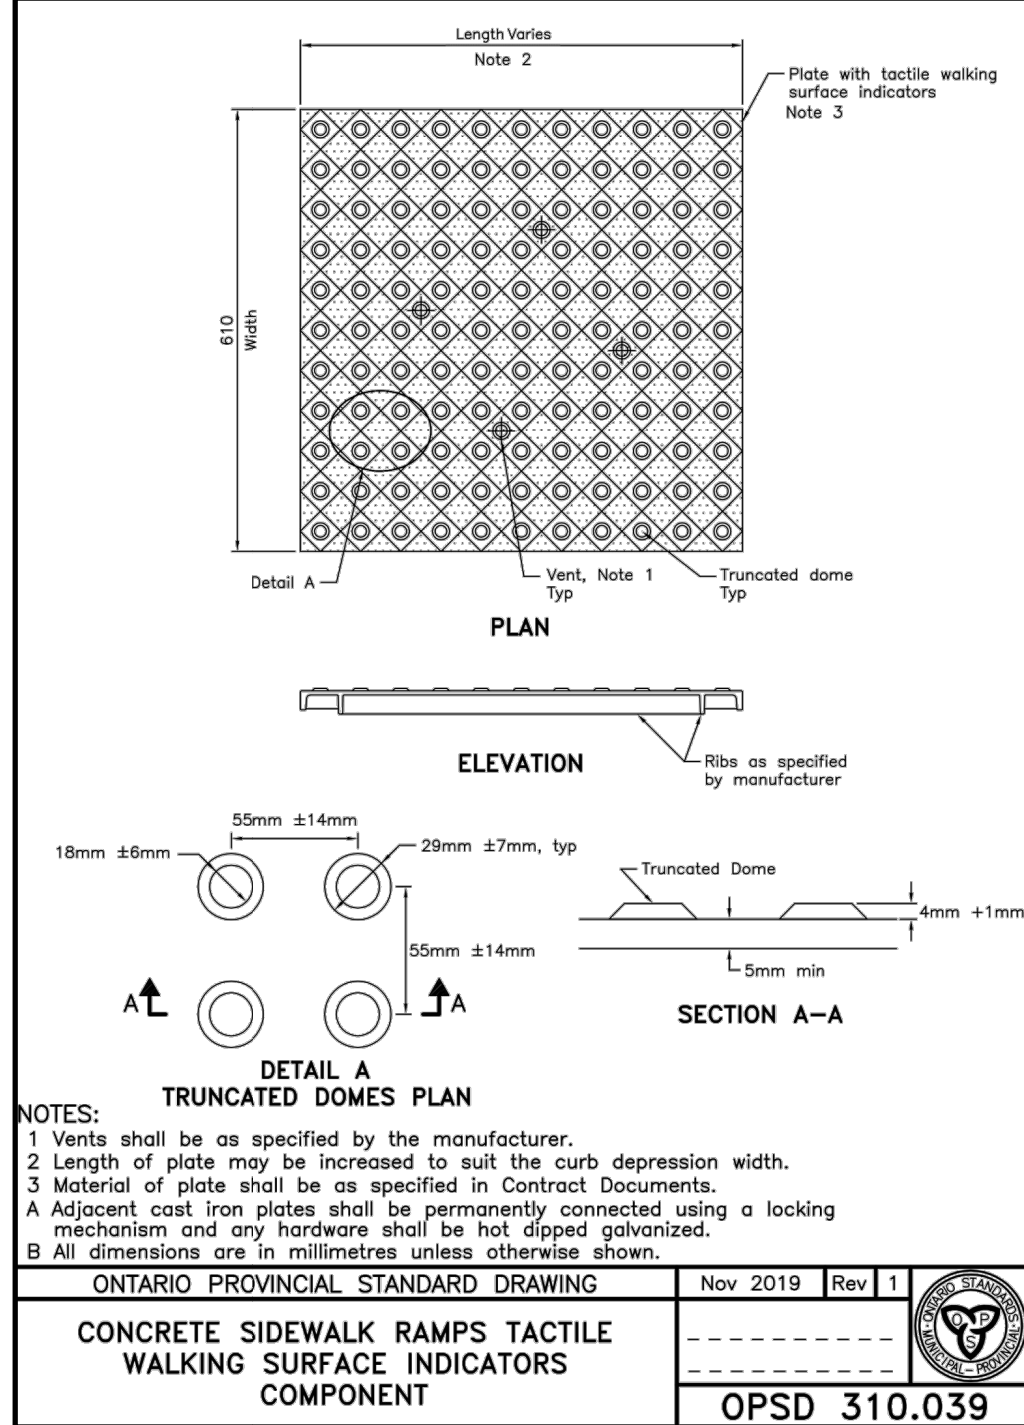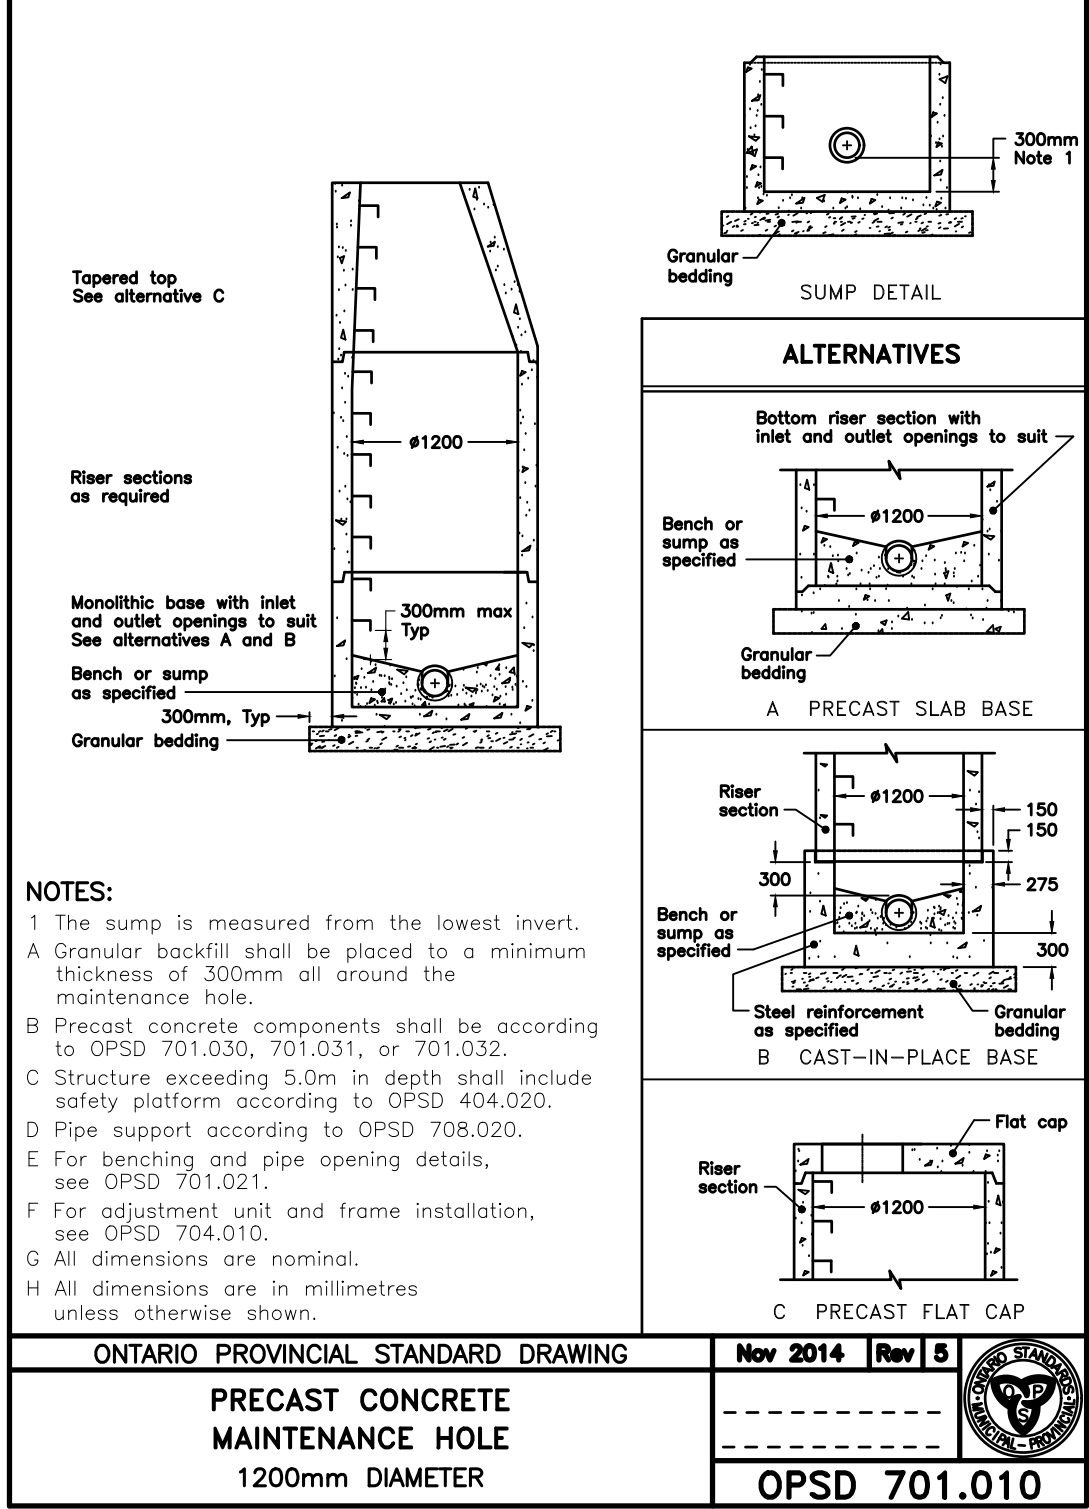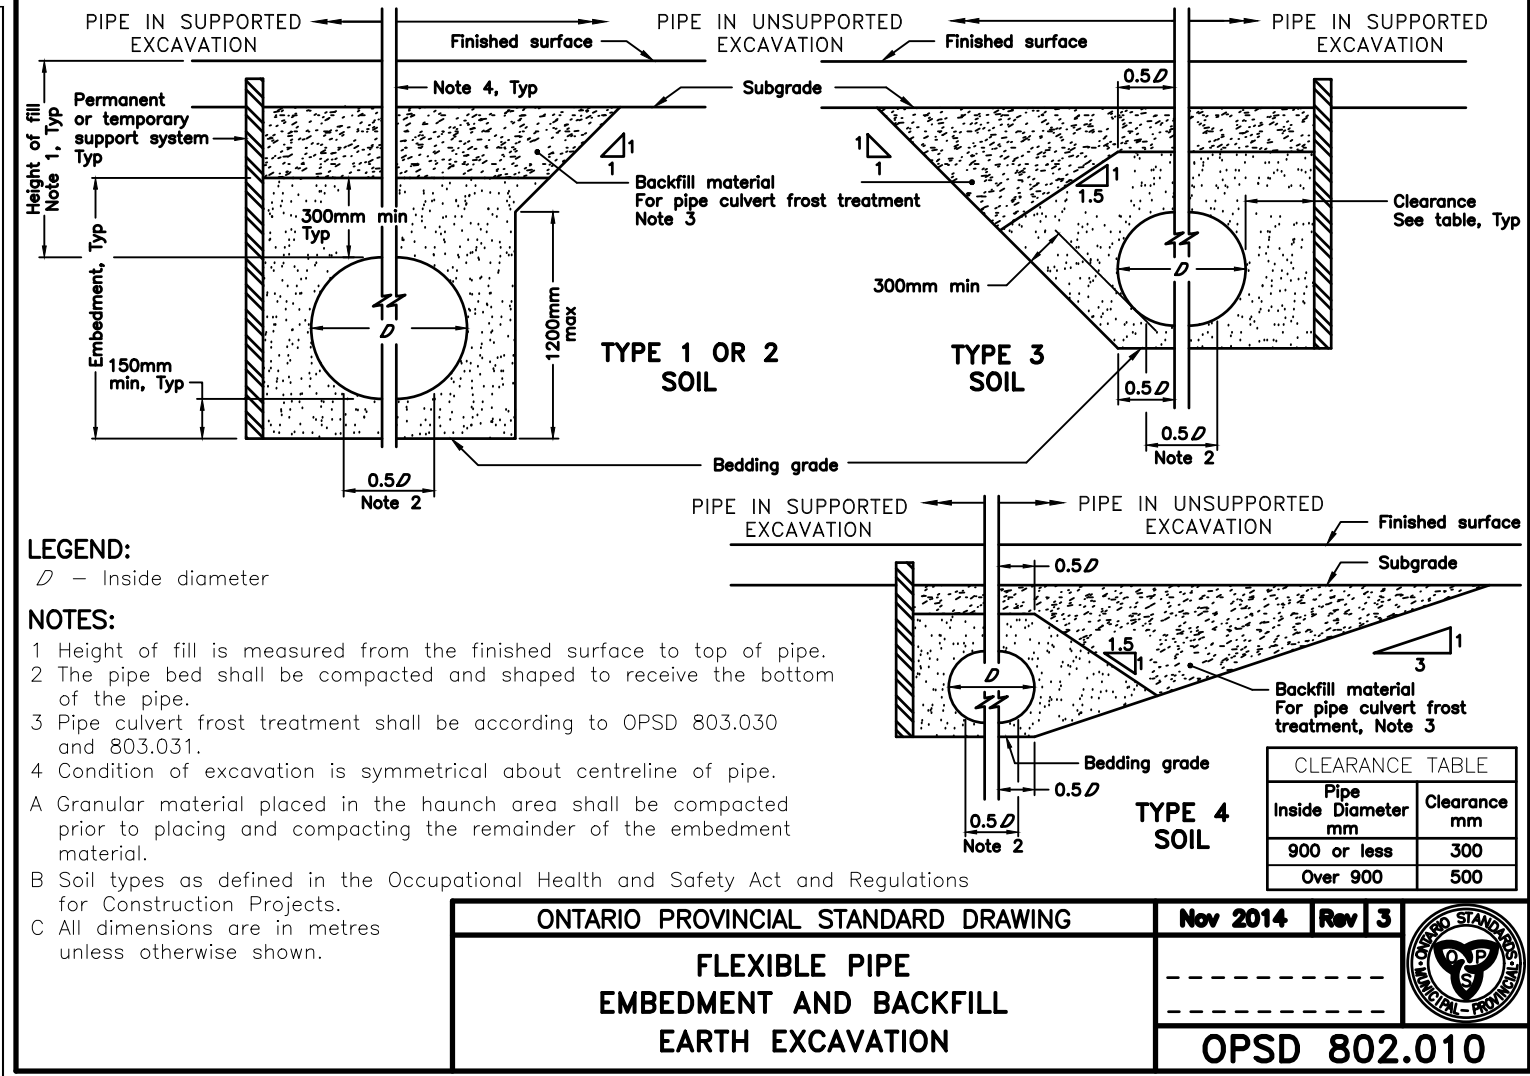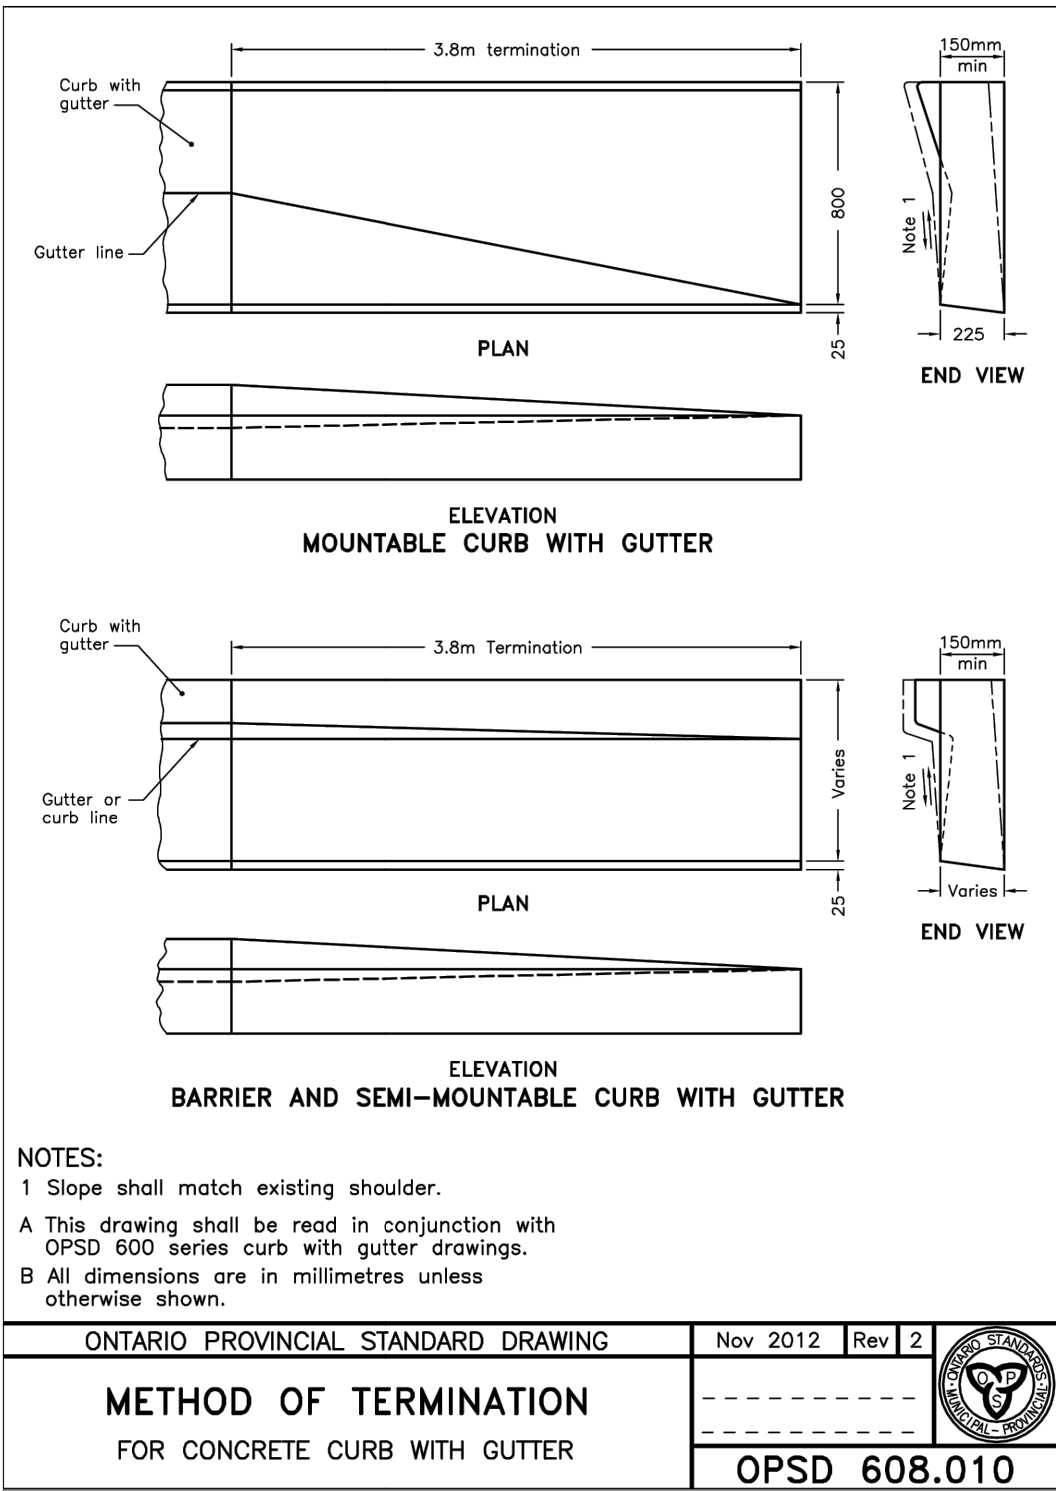

3	AUG 13/26	ISSUED FOR TENDER	JHL	TLB
2	JUN 10/26	SECOND SUBMISSION	JHL	TLB
1	APR 10/26	FIRST SUBMISSION	JHL	TLB
No.	DATE	DESCRIPTION	BY	APPD

REVISION / ISSUE

Seal not valid unless signed and dated

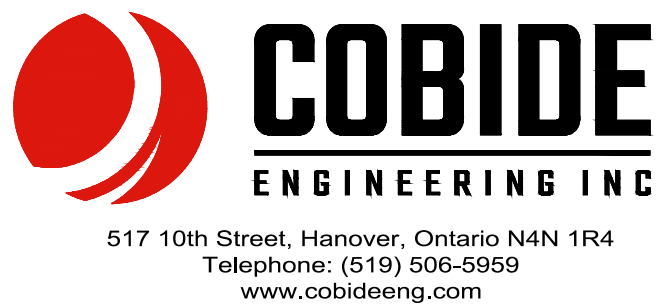

Title:		341 10TH STREET TOWN OF HANOVER HANOVER POLICE STATION DETAILS 2	
Client:		+VG ARCHITECTS	
Design:	TLB	Scale:	-
Drawn:	SEH/JHL	Approved:	
Checked:	TLB		
Date:	MAR 2026		
DRAWING No.		10048-DET2	
		Design Engineer	